

ROCK RIVER WATER RECLAMATION DISTRICT


WEST STATE STREET SANITARY SEWER CAPITAL IMPROVEMENT PROJECT NO. 2014 2021

BOARD OF TRUSTEES


RICHARD POLLACK PRESIDENT
JOHN SWEENEY VICE-PRESIDENT
BEN BERNSTEN CLERK/TREASURER
DONALD MASSIER TRUSTEE
ELMER JONES TRUSTEE

OFFICIALS

TIMOTHY S. HANSON EXECUTIVE DIRECTOR
CHRISTOPHER T. BAER, PE DIRECTOR OF ENGINEERING

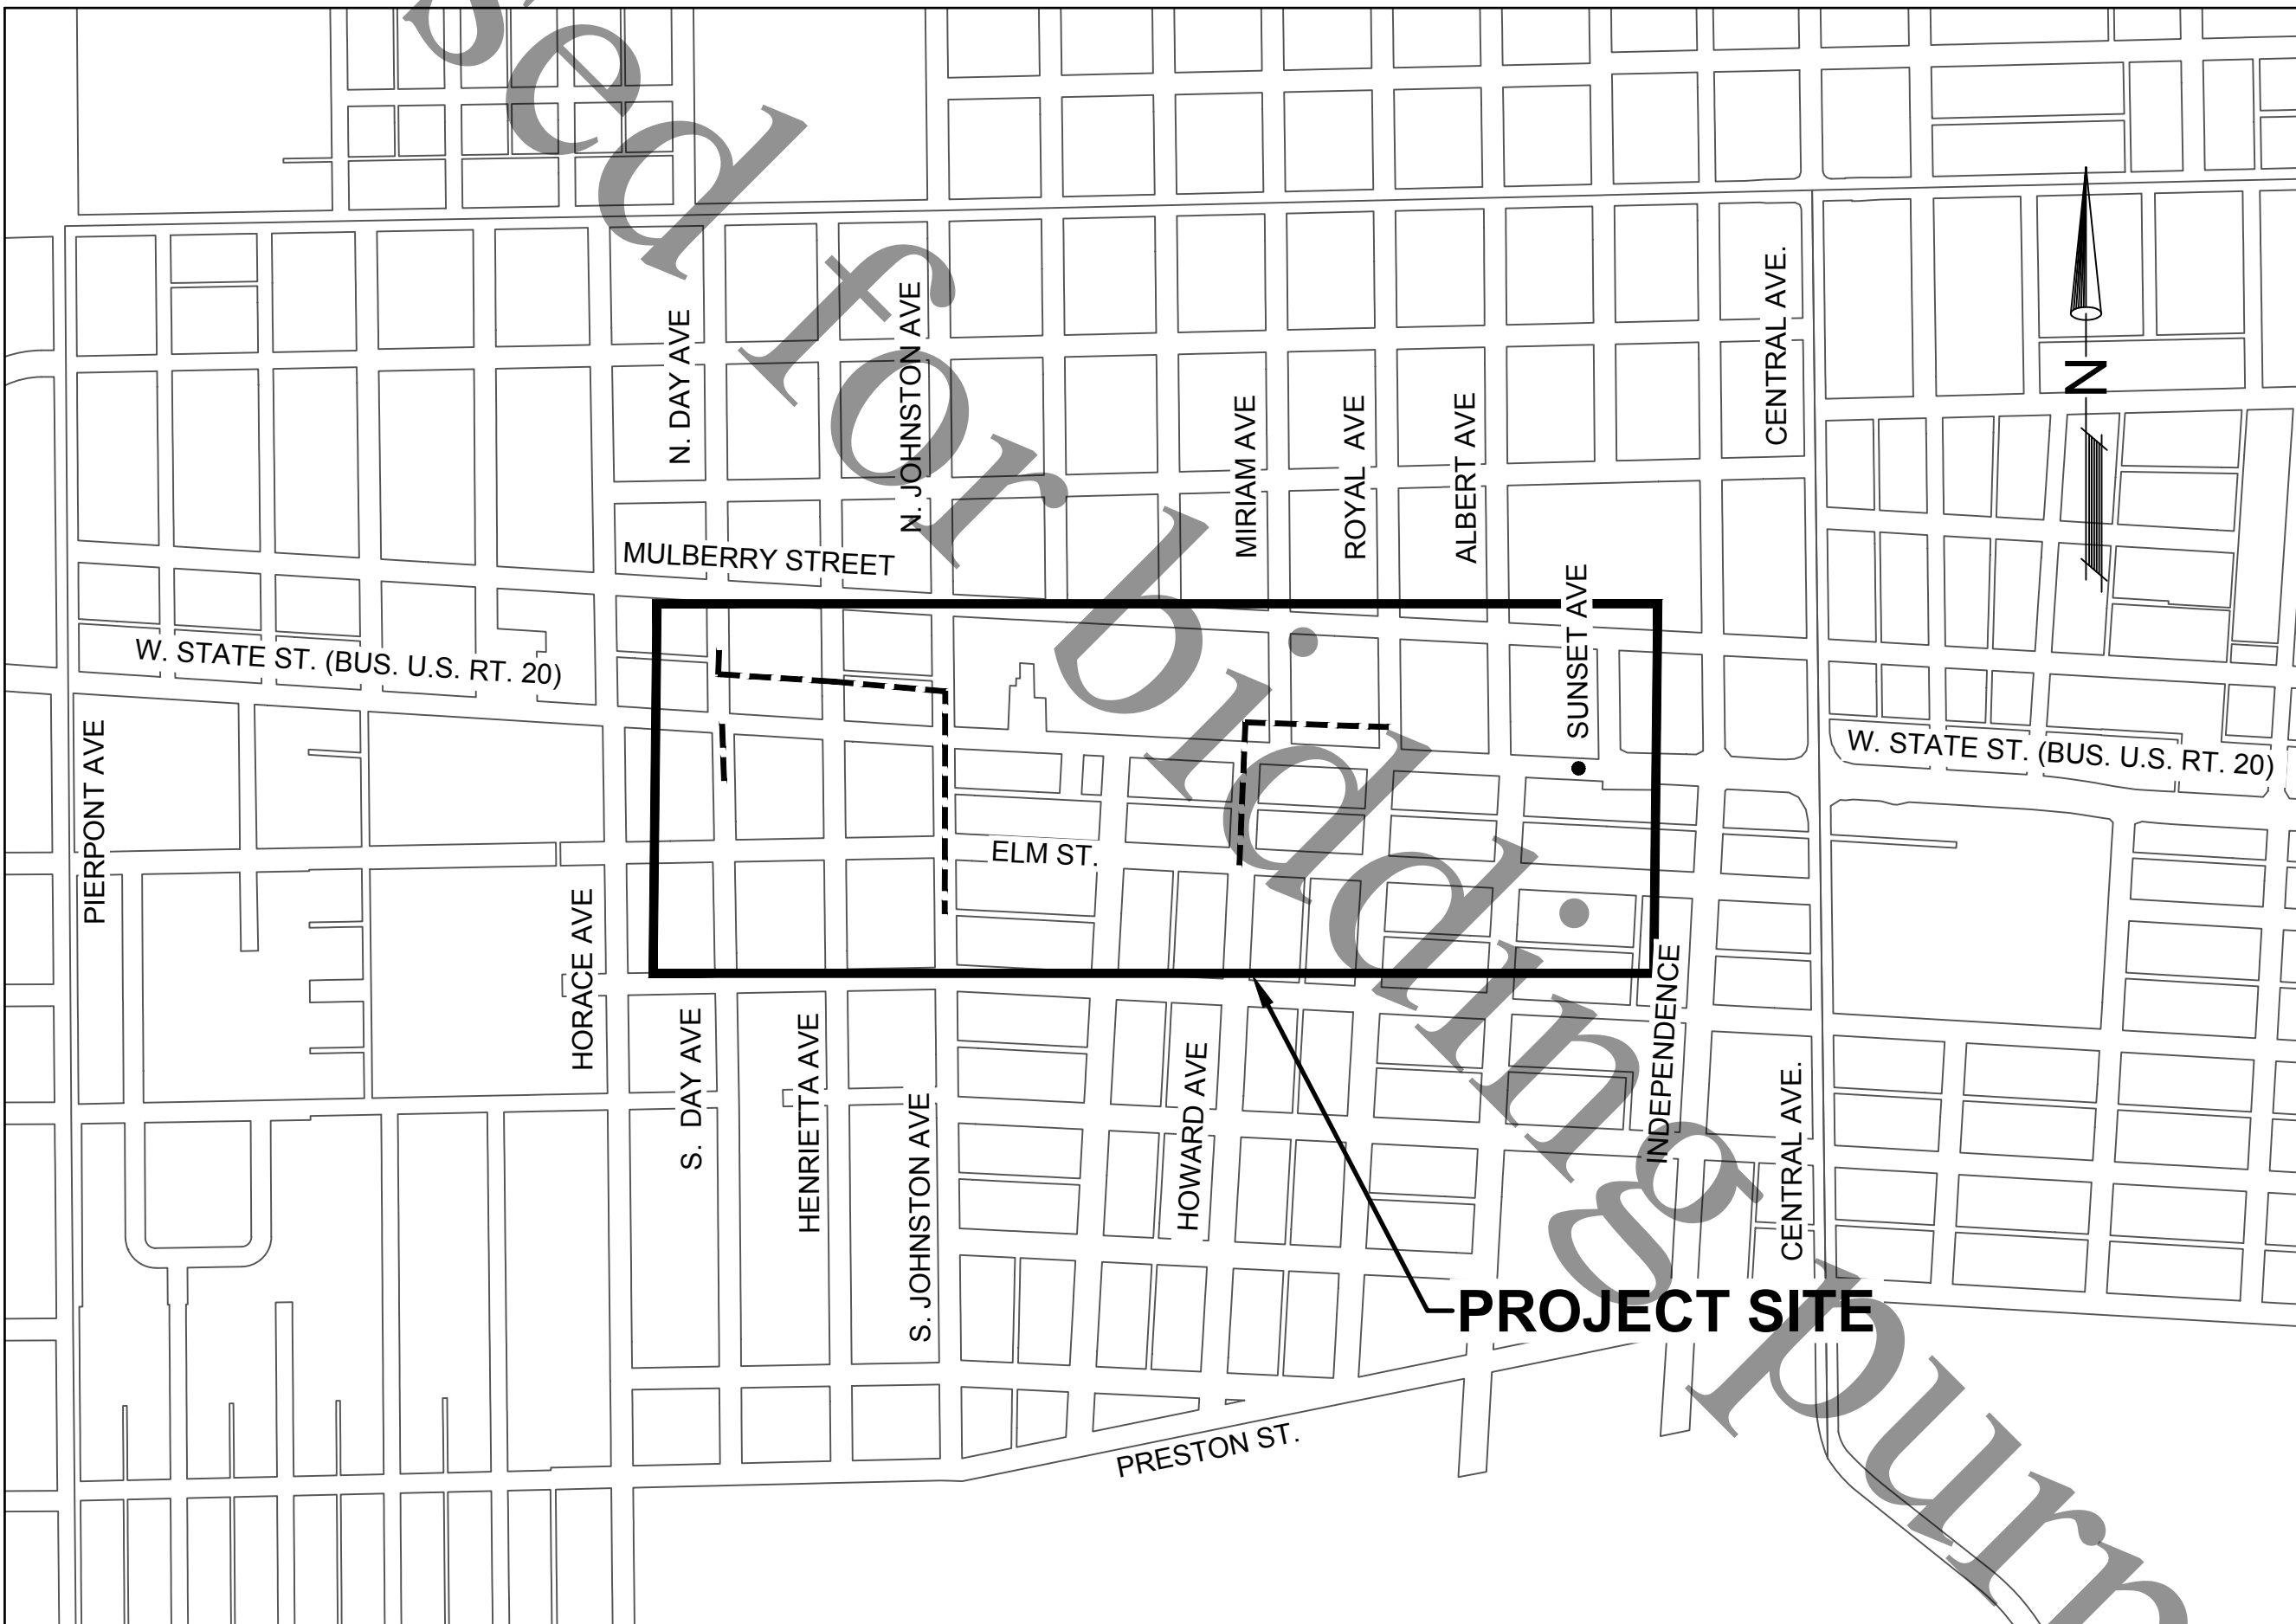

ROCKFORD, ILLINOIS

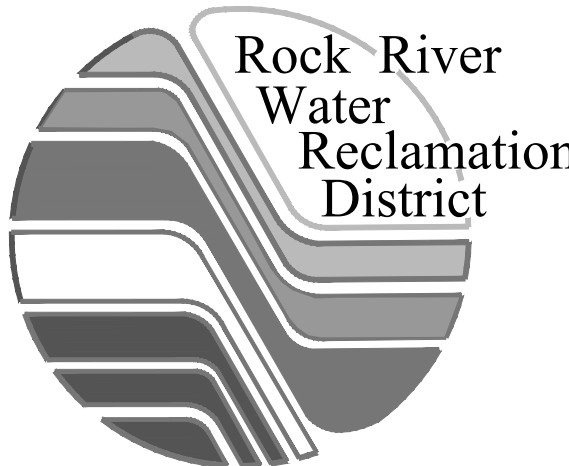

INDEX OF SHEETS

1. COVER
2. LEGEND, GENERAL NOTES, SUMMARY OF QUANTITIES
3. SEWER ABANDONMENT PLAN
4. PLAN & PROFILE - S. DAY AVE.
5. PLAN & PROFILE - S. JOHNSTON AVE
6. PLAN & PROFILE - N. JOHNSTON AVE.
7. PLAN & PROFILE - JOHNSTON TO HENRIETTA
8. PLAN & PROFILE - HENRIETTA TO N. DAY AVE.
9. PLAN & PROFILE - HOWARD AVE TO W. STATE ST.
10. PLAN & PROFILE - MIRIAM AVE. TO ROYAL AVE.
11. PLAN & PROFILE - W. STATE (ROYAL-ALBERT-SUNSET)
12. TRAFFIC CONTROL PLAN
13. DETAILS
14. DETAILS
15. R.R.W.R.D. STANDARD DETAILS



LEGEND

EXISTING

PROPOSED

	RIGHT OF WAY LINE
	PROPERTY LINE
	BUILDING
	WATER EDGE
	EASEMENT - PERMANENT SANITARY
	EASEMENT - TEMPORARY CONSTRUCTION
	VEGETATION / TREE LINE
	TREE DRIPLINE
	CONTOUR - MAJOR
	CONTOUR - MINOR
	FENCE
	FENCE - TEMPORARY CONSTRUCTION
	FENCE - SILT
	ROADWAY CENTERLINE
	EDGE OF PAVEMENT
	CURB & GUTTER
	GUARD RAIL
	RAILROAD TRACKS
	CABLE - OVERHEAD
	CABLE - UNDERGROUND
	ELECTRIC - OVERHEAD
	ELECTRIC - UNDERGROUND
	FIBER OPTIC
	GAS LINE
	TELEPHONE - OVERHEAD
	TELEPHONE - UNDERGROUND
	PEDESTALS (CATV, ELEC, TELE), HANDHOLE, GAS METER, ELEC. METER
	ELECTRIC MANHOLE
	SOIL BORING
	BENCHMARK & CONTROL POINT
	MAILBOX
	UTILITY POLE W/ GUY WIRE & MAST ARM LIGHT POLE
	TREE (DECIDUOUS & CONIFEROUS)
	BUSH & SHRUB
	GROUND / LANDSCAPE LIGHT
	SPOT ELEVATION

LEGEND

EXISTING

PROPOSED

	SANITARY MANHOLE & SANITARY SEWER
	SANITARY SEWER SERVICE & CLEANOUT
	SANITARY FORCEMAIN
	STORM SEWER
	STORM MANHOLE, CATCH BASIN, CURB INLET, INLET SPECIAL
	DRAINAGE CULVERT, WITH END SECTION
	WATER MAIN
	WATER SERVICE & WATER SERVICE VALVE
	WATER MAIN VALVE
	WATER MAIN VALVE WITH BOX
	WATER MAIN VALVE WITH VAULT
	WATER MAIN LINESTOP
	FIRE HYDRANT
	EXISTING SURFACE TYPE (HOT-MIX ASPHALT, AGGREGATE CONCRETE, TURF)
	DITCH CHECK
	INLET OR PIPE PROTECTION
	STABILIZED CONSTRUCTION ENTRANCE
	EROSION CONTROL BLANKET
	HEAVY DUTY EROSION CONTROL BLANKET
	SEEDING AREA, CLASS 1
	SEEDING AREA, CLASS 3
	PAVEMENT REPLACEMENT
	DRIVEWAY REPLACEMENT
	AGGREGATE REPLACEMENT
	RIP RAP

ABBREVIATIONS

ABD = ABANDON(ED)	LS= LUMP SUM
CMP = CORRUGATED METAL PIPE	MH = MANHOLE
CO = CLEAN OUT	PVMNT = PAVEMENT
CTRL= CONTROL	PRC = PRECAST REINFORCED CONCRETE
CY = CUBIC YARD(S)	PR = PROPOSED
DI = DUCTILE IRON	RCP = REINFORCED CONCRETE PIPE
EA = EACH	REM = REMOVE(D)
EL = ELEVATION	REPL = REPLACE(D)
EROS= EROSION	R/R = REMOVE & REPLACE
EX = EXISTING	SAN = SANITARY
FES = FLARED END SECTION	SVC = SERVICE
FM = FORCE MAIN	SY = SQUARE YARD(S)
FT = FEET	TY = TYPE
INV = INVERT	UNK = UNKNOWN
LF = LINEAR FEET	VCP = VITRIFIED CLAY PIPE
LINCIPP = LINED WITH CURED IN PLACE PIPE	WM = WATER MAIN

GENERAL NOTES

1. THE CONTRACTOR IS SOLELY RESPONSIBLE FOR EXECUTION OF WORK TO THE LINES AND GRADES SHOWN ON THESE PLANS. CONSTRUCTION SHALL NOT VARY FROM PLANS WITHOUT DISTRICT APPROVAL.
2. THE ROCK RIVER WATER RECLAMATION DISTRICT, MUNICIPALITIES, PERTINENT ROADWAY AUTHORITIES, AND ALL AFFECTED PROPERTY OWNERS SHALL BE NOTIFIED AT LEAST 48 HOURS BEFORE CONSTRUCTION CAN COMMENCE.
3. ALL SERVICE LOCATIONS ARE APPROXIMATE AND MAY BE CHANGED IN THE FIELD WITH THE APPROVAL OF THE INSPECTOR. NO ADDITIONAL COMPENSATION WILL BE AWARDED DUE TO REVISED LOCATION.
4. ALL CASTINGS SHALL BE SET TO FINAL GRADE PER ROCK RIVER WATER RECLAMATION DISTRICT REQUIREMENTS.
5. SANITARY SEWER SHALL BE CONSTRUCTED IN ACCORDANCE WITH THE STANDARD SPECIFICATIONS FOR WATER AND SEWER CONSTRUCTION IN THE STATE OF ILLINOIS, LATEST EDITION, AND THE REQUIREMENTS OF THE ROCK RIVER WATER RECLAMATION DISTRICT.
6. THE CONTRACTOR SHALL VERIFY THE LOCATION OF ALL UTILITIES IN THE FIELD PRIOR TO CONSTRUCTION. THE CONTRACTOR SHALL NOTIFY J.U.L.I.E. AT 8-1-1 OR 1-800-892-0123 AND ANY OTHER UTILITIES NOT ON THE J.U.L.I.E. SYSTEM 48 HOURS PRIOR TO THE START OF CONSTRUCTION.
7. ALL ROADWAY CONSTRUCTION SHALL BE COMPLETED IN ACCORDANCE WITH THE ROADWAY AUTHORITY'S REQUIREMENTS, DISTRICT SPECIFICATIONS, AND THE STANDARD SPECIFICATION FOR ROAD AND BRIDGE CONSTRUCTION IN ILLINOIS, LATEST EDITION.
8. THE CONTRACTOR SHALL COMPLY WITH ALL REQUIREMENTS OF THE I.E.P.A. STANDARDS AND SPECIFICATIONS, AND THE ILLINOIS URBAN MANUAL FOR SOIL EROSION AND SEDIMENT CONTROL.
9. PROTECTION OF WATER SUPPLIES SHALL BE PER THE REQUIREMENTS OF TITLE 35, C. SECTION 370.350 OF THE ILLINOIS RECOMMENDED STANDARDS FOR SEWAGE WORKS.

SPECIAL CONSIDERATIONS

NO WORK SHALL BE PERFORMED WITHIN ILLINOIS DEPARTMENT OF TRANSPORTATION (IDOT) RIGHT-OF-WAY UNTIL THE DETOUR DETAILED IN THESE PLANS IS ESTABLISHED. THROUGH COLLABORATION WITH IDOT, THE RRRWD HAS ARRANGED FOR THE DETOUR OF WEST STATE STREET TO BE ESTABLISHED UNDER SEPARATE CONTRACT. THE DETOUR WILL BE ESTABLISHED ON OR ABOUT AUGUST 15, AND REMAIN IN PLACE FOR SIXTY (60) CALENDAR DAYS TO ALLOW FOR UTILITY WORK, INCLUDING THIS SANITARY SEWER CONTRACT. ANY ADDITIONAL TRAFFIC CONTROL REQUIRED FOR STAGING, AS DETERMINED BY THE CONTRACTOR, SHALL BE HIS OR HER RESPONSIBILITY AT NO ADDITIONAL COST TO THE RRRWD. TRAFFIC CONTROL FOR LOCAL STREETS REQUIRED OUTSIDE OF THE SIXTY CALENDAR DAYS PROVIDED FOR SHALL BE PAID AT THE CONTRACT LUMP SUM UNIT PRICE FOR TRAFFIC CONTROL AND PROTECTION, LOCAL STREETS. SHOULD THE CONTRACTOR REQUIRE MORE THAN SIXTY (60) CALENDAR DAYS FOR WORK WITHIN IDOT RIGHT-OF-WAY, IT SHALL BE THE CONTRACTOR'S RESPONSIBILITY TO PERMIT, ESTABLISH AND MAINTAIN TRAFFIC CONTROL WITHIN IDOT RIGHT-OF-WAY AT NO ADDITIONAL COST TO THE RRRWD.

EXPLANATION OF PROJECT STAGING

PROPOSED WORK, NOTED AS "IDOT" OR "BY OTHERS" WILL BE PERFORMED UNDER SEPARATE CONTRACT UPON THE COMPLETION OF THIS PROJECT.

THESE COMPONENTS ARE SHOWN WITH THE INTENT TO CLARIFY THE FULL SCOPE/INTENT OF THIS PROJECT AND/OR DESIGN COMPONENT THEREOF TO PROSPECTIVE BIDDERS.

PROPOSED PLANS CONTINGENT UPON CITY OF ROCKFORD ROW
PERMIT ISSUANCE AND/OR SANITARY SEWER EASEMENT ACQUISITION
FROM CITY OF ROCKFORD

PROPOSED SANITARY MANHOLES

PROPOSED MANHOLE NO.	NORTHING	EASTING
1	2044375.4285'	2579170.6513'
2	2045110.2291'	2579197.0530'
3	2045111.2100'	2579285.5314'
4	2045114.8586'	2579614.6408'
5	2044547.7180'	2578276.7641'
6	2044887.3469'	2578273.9296'
7	2045204.8090'	2578271.0232'
8	2045224.3750'	2577937.2651'
9	2045244.3086'	2577597.2364'
20	2044966.2201'	2577609.4426'
21	2045069.6388'	2577608.4369'
30	2044949.8702'	2580144.6600'

SUMMARY OF QUANTITIES

ITEM	DESCRIPTION	QUANTITY	UNIT
1	SANITARY SEWER, SDR 35 PVC, 8" DIA.	2,387	LF
2	SANITARY MANHOLE, 4' DIA.	10	EA
3	SANITARY MANHOLE, 5' DIA.	2	EA
4	SANITARY MANHOLE, 5' DIA. INSIDE DROP	1	EA
5	SANITARY SEWER SERVICE, COMPLETE, 4" DIA.	7	EA
6	SANITARY SEWER SERVICE, COMPLETE, 6" DIA.	6	EA
7	SANITARY MANHOLE REMOVAL	9	EA
8	ABANDON AND FILL SANITARY MANHOLE	10	EA
9	ABANDON AND FILL SANITARY SEWER, VARIOUS DIA.	1	LS
10	ROCK EXCAVATION, SANITARY SEWER	725	CY
11	PAVEMENT REMOVAL	2,692	SY
12	PAVMENT PATCHING, CLASS D, 6"	2,692	SY
13	PCC CURB AND GUTTER REMOVAL AND REPLACEMENT	298	LF
14	PCC DRIVEWAY REMOVAL AND REPLACEMENT, 6"	38	SY
15	PCC SIDEWALK, REMOVAL AND REPLACEMENT, 4"	1,662	SF
16	AGGREGATE BASE COURSE, TYPE B, 12"	2,692	SY
17	PAINT PAVEMENT MARKING, LINE 4, WHITE	180	LF
18	PAINT PAVEMENT MARKING, LINE 4, YELLOW	840	LF
19	PAINT PAVEMENT MARKING, LINE 24, WHITE	60	LF
20	TREE REMOVAL	1	LS
21	TEMPORARY CONSTRUCTION FENCE	100	LF
22	PERIMETER SILT FENCE	1,133	LF
23	INLET PROTECTION	29	EA
24	TURF RESTORATION, 6" TOPSOIL, CLASS 1 SEEDING, FERTILIZER	0.7	ACRE
25	CONSTRUCTION LAYOUT	1	LS
26	TRAFFIC CONTROL AND PROTECTION (LOCAL STREETS)	1	LS

PAINT PAVEMENT MARKINGS

4" WHITE - CROSSWALK	
STA. 6+94	90LF
STA. 7+55	90LF
4" YELLOW - DOUBLE LANE LINE	
STA. 4+30 - 6+90	520LF
STA. 7+60 - 9+20	320LF
24" WHITE STOP BAR	
STA. 3+40 RT (S. DAY AVE)	18LF
STA. 6+88 RT	21LF
STA. 7+63 LT	21LF

FINAL LAYOUT OF PAVEMENT MARKING
SHALL BE AS DIRECTED BY THE RRWRD

CONTROL POINTS

POINT NO.	NORTHING	EASTING	STATION / OFFSET	DESCRIPTION
CP 1	2045117.7100	2045117.7100	4+09, 8LT	CUT "X"
CP 3	2045078.8300	2578232.3600	7+53, 40LT	CUT "X"
CP 5	2044968.2900	2579236.9000	52+96, 40RT	CUT "X"
CP 6	2045017.3300	2579645.1200	58+82, 98RT	CUT "X"
CP 31	2045278.0100	2577617.6700	15+87, 20RT	CUT "X"
CP 32	2045248.8400	2577906.4600	12+45, 22RT	CUT "X"
CP 33	2045222.2800	2578253.3100	8+97, 16RT	CUT "X"
CP 35	2044752.4500	2578299.9800	4+26, 25RT	CUT "X"
CP 36	2044555.2500	2578306.1100	2+28, 29RT	CUT "X"
CP 7	2044932.7700	2579914.7300	236+86, 29RT	CUT "X"



**ROCK RIVER WATER
RECLAMATION DISTRICT
3501 KISHWAUKEE STREET
ROCKFORD, ILLINOIS 61109
(815) 387-7660**

No.	DATE	REVISION	INT.

**WEST STATE STREET SANITARY SEWER
CAPITAL IMPROVEMENT PROJECT NO. 2014**


LEGEND & GEN NOTES & SUM OF QTYS

FOR BID

Sheet No.
2 OF 15

Date
6/2/2021

file: I:\District Projects\W State St Ph 2-2019 Sewer Rehab 081401 Design\Drawings\C3D Working\2019 W State\W State 2019.dwg

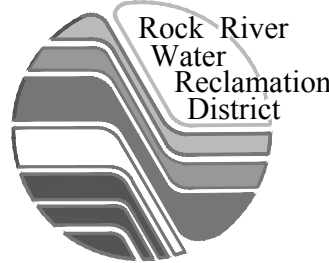

**ROCK RIVER WATER
RECLAMATION DISTRICT**
3501 KISHWAUKEE STREET
ROCKFORD, ILLINOIS 61109
(815) 387-7660

No.	DATE	REVISION	INT.


**WEST STATE STREET SANITARY SEWER
CAPITAL IMPROVEMENT PROJECT NO. 2014**

MANHOLE & MAIN ABANDONMENT



Sheet No.
3 OF 15

Date
6/2/2021

FOR BID

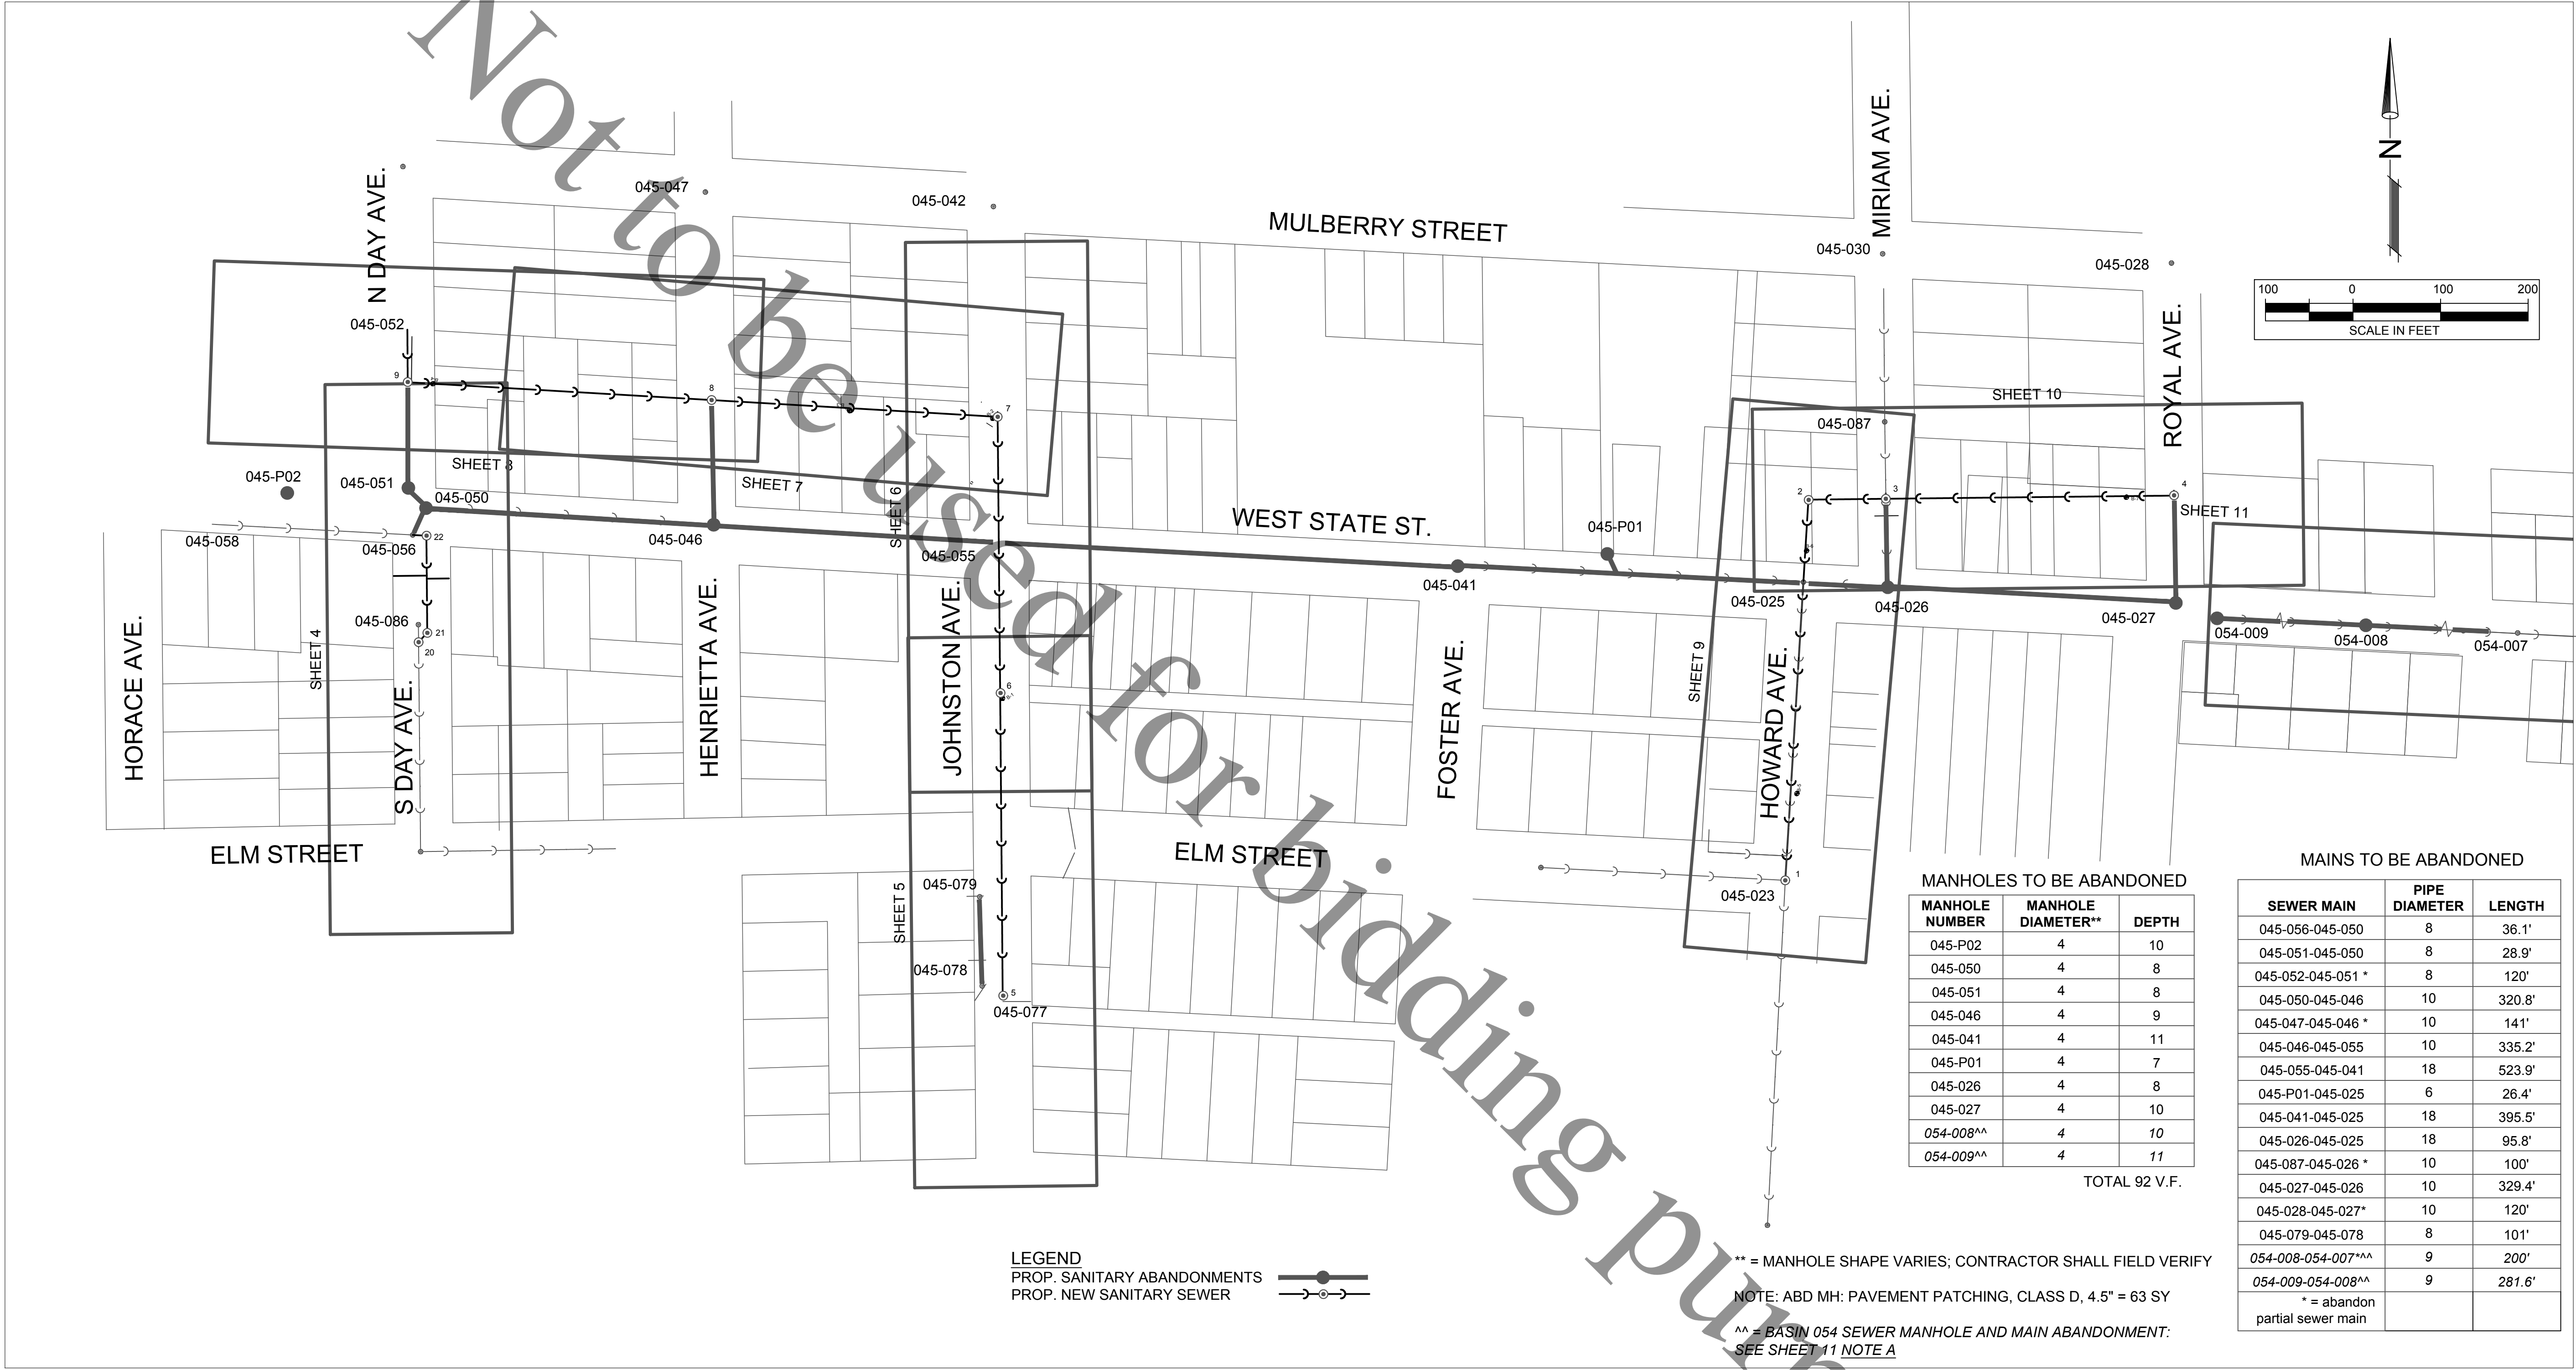

file: I:\District Projects\W State St Ph 2-2019 Sewer Rehab 081401 Design\Drawings\C3D Working\2019 W State\W State 2019.dwg

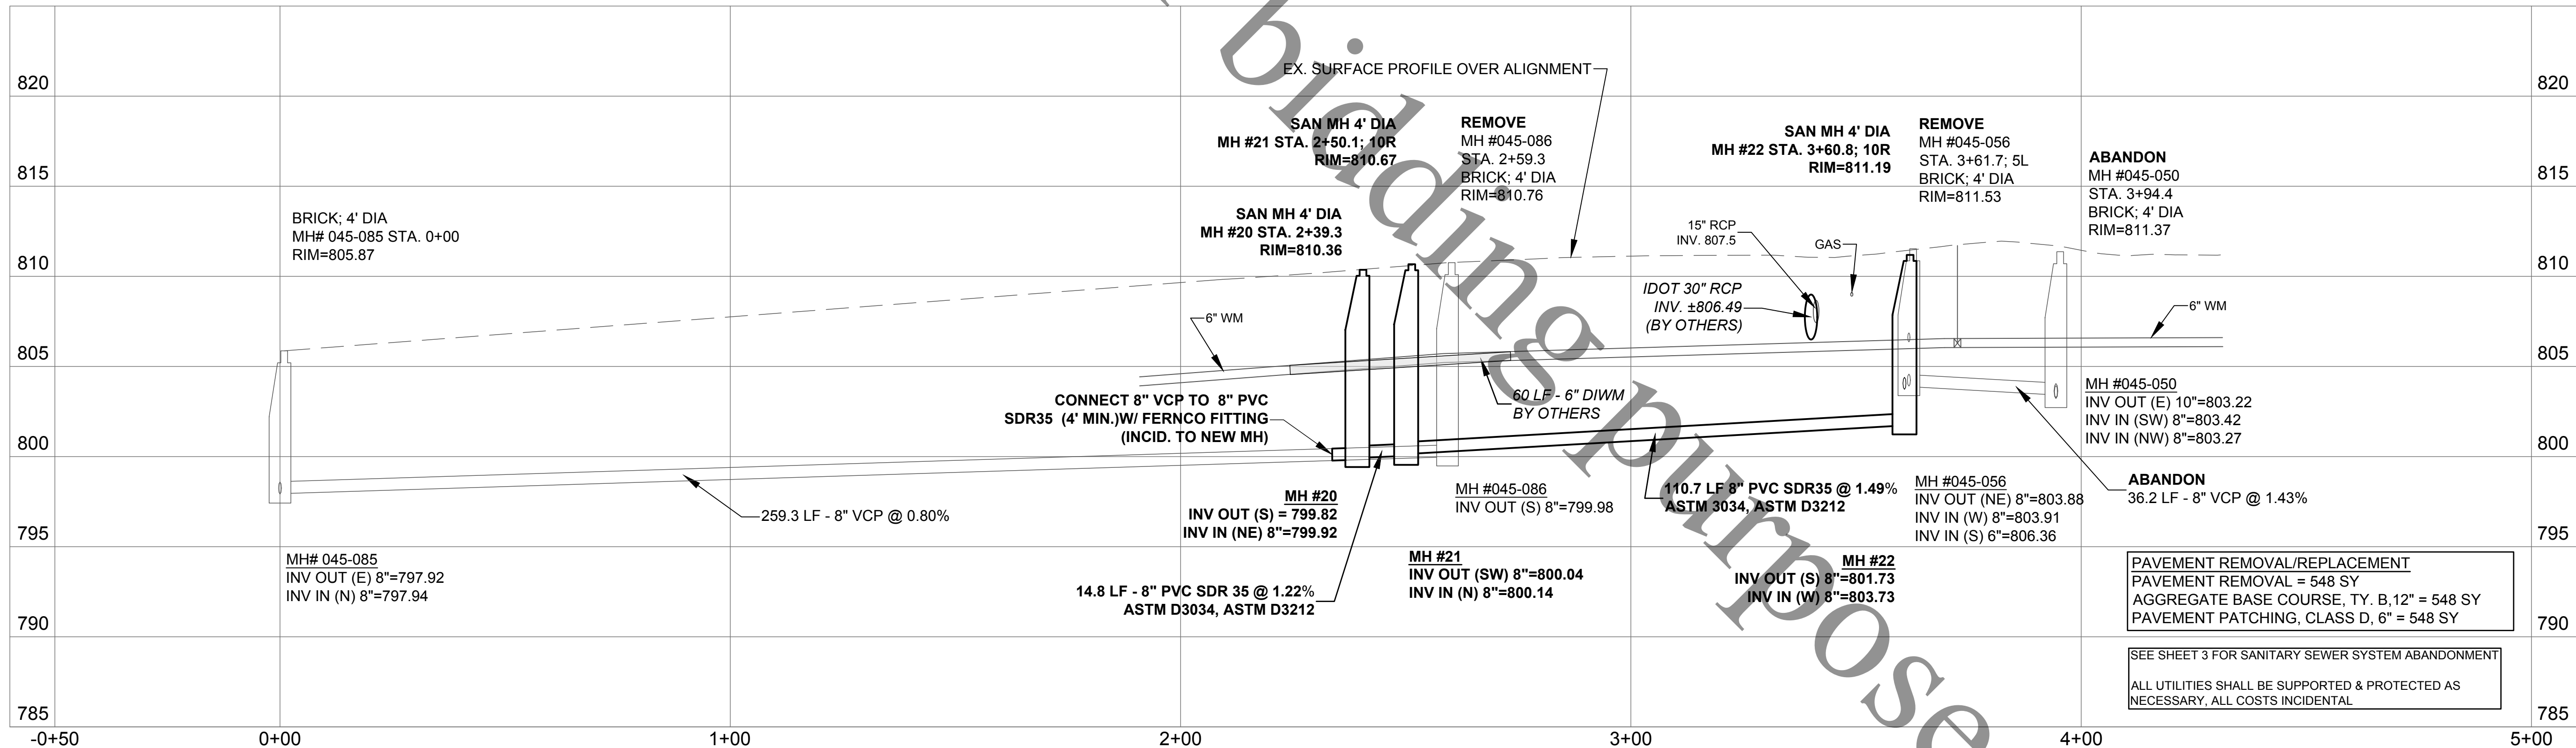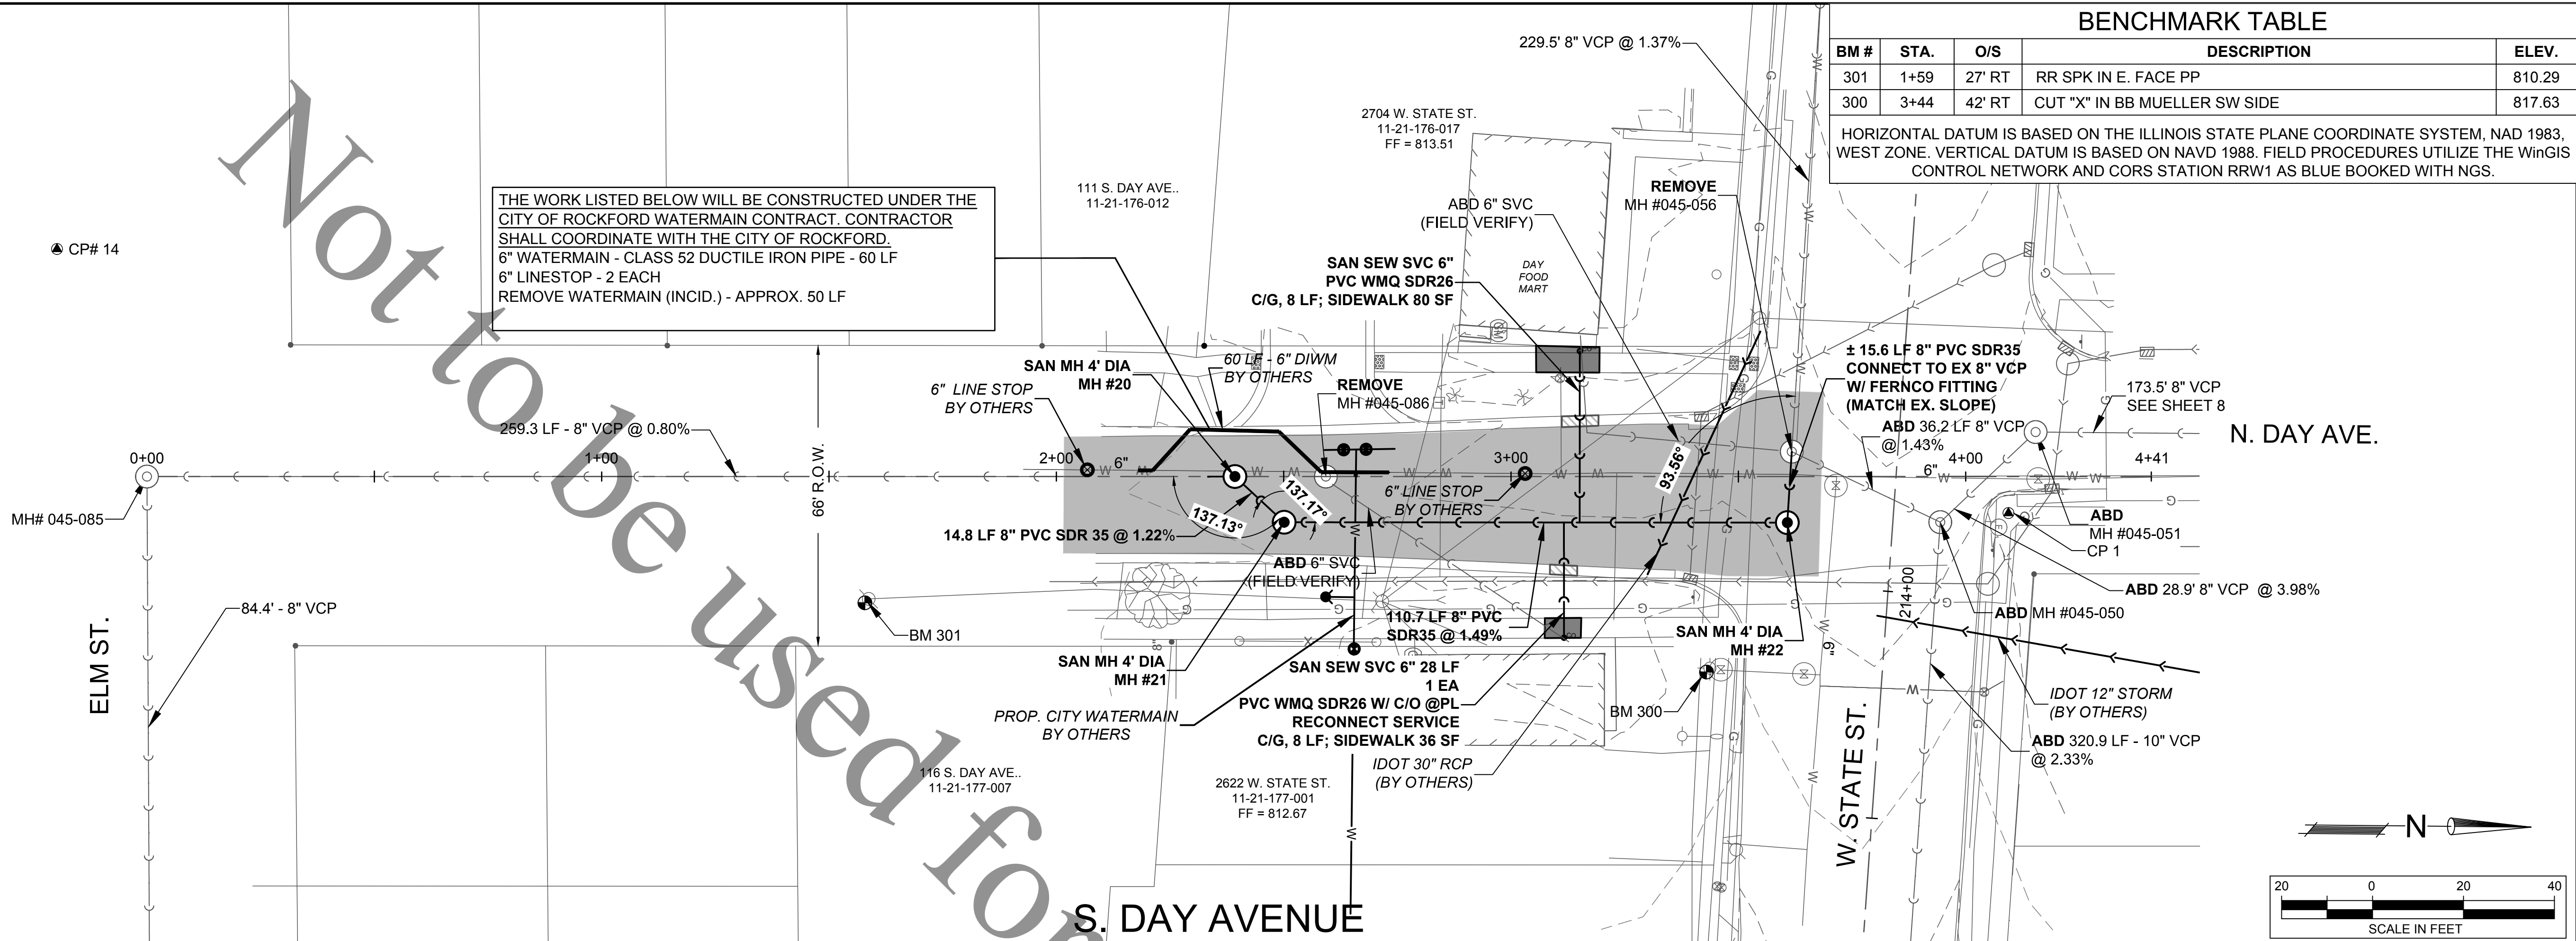

ROCK RIVER WATER
RECLAMATION DISTRICT
3501 KISHWAUKEE STREET
ROCKFORD, ILLINOIS 61109
(815) 387-7660

No.	DATE	REVISION	INT.

WEST STATE STREET SANITARY SEWER
CAPITAL IMPROVEMENT PROJECT NO. 2014




S. DAY AVE. - W. STATE ST.

FOR BID

Sheet No.
4 OF 15

Date
6/2/2021

file: I:\District Projects\W State St Ph 2-2019 Sewer Rehab 081401 Design\Drawings\C3D Working\2019 W State\W State 2019.dwg

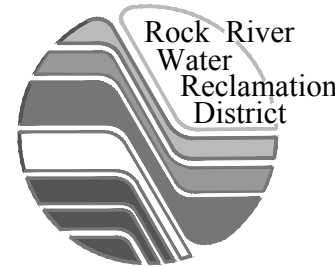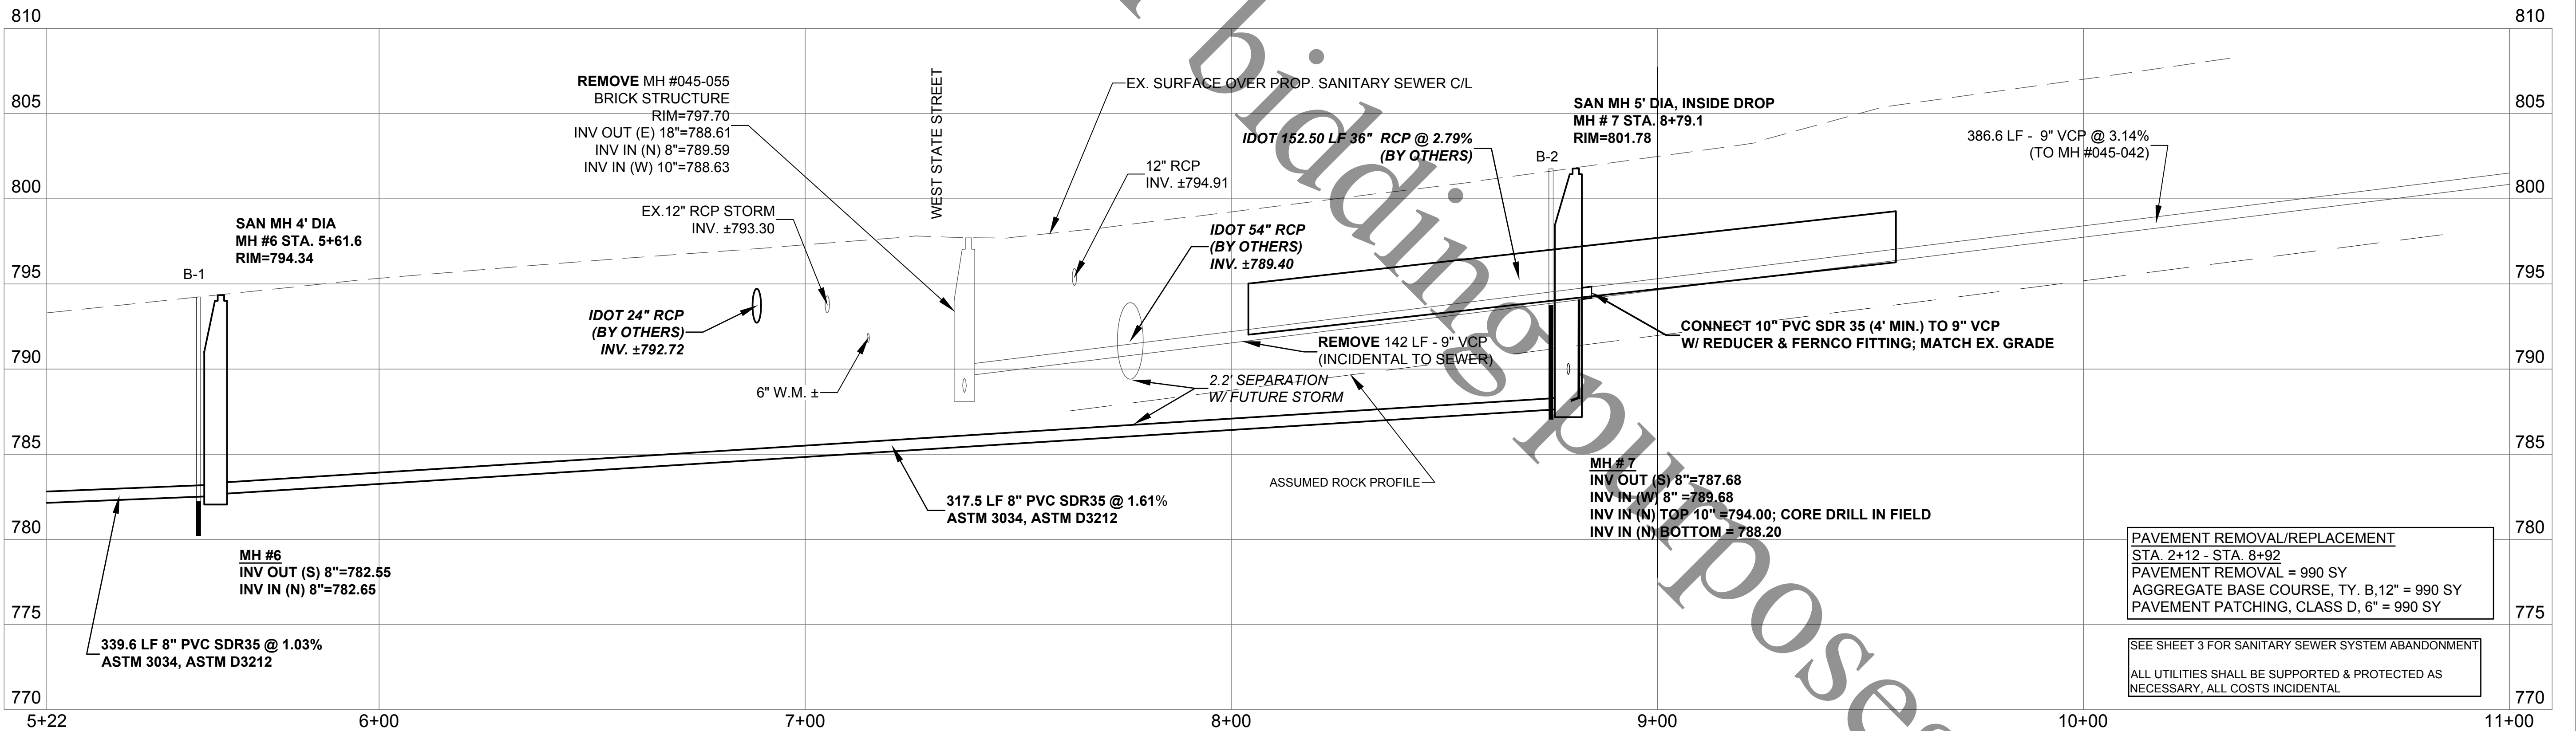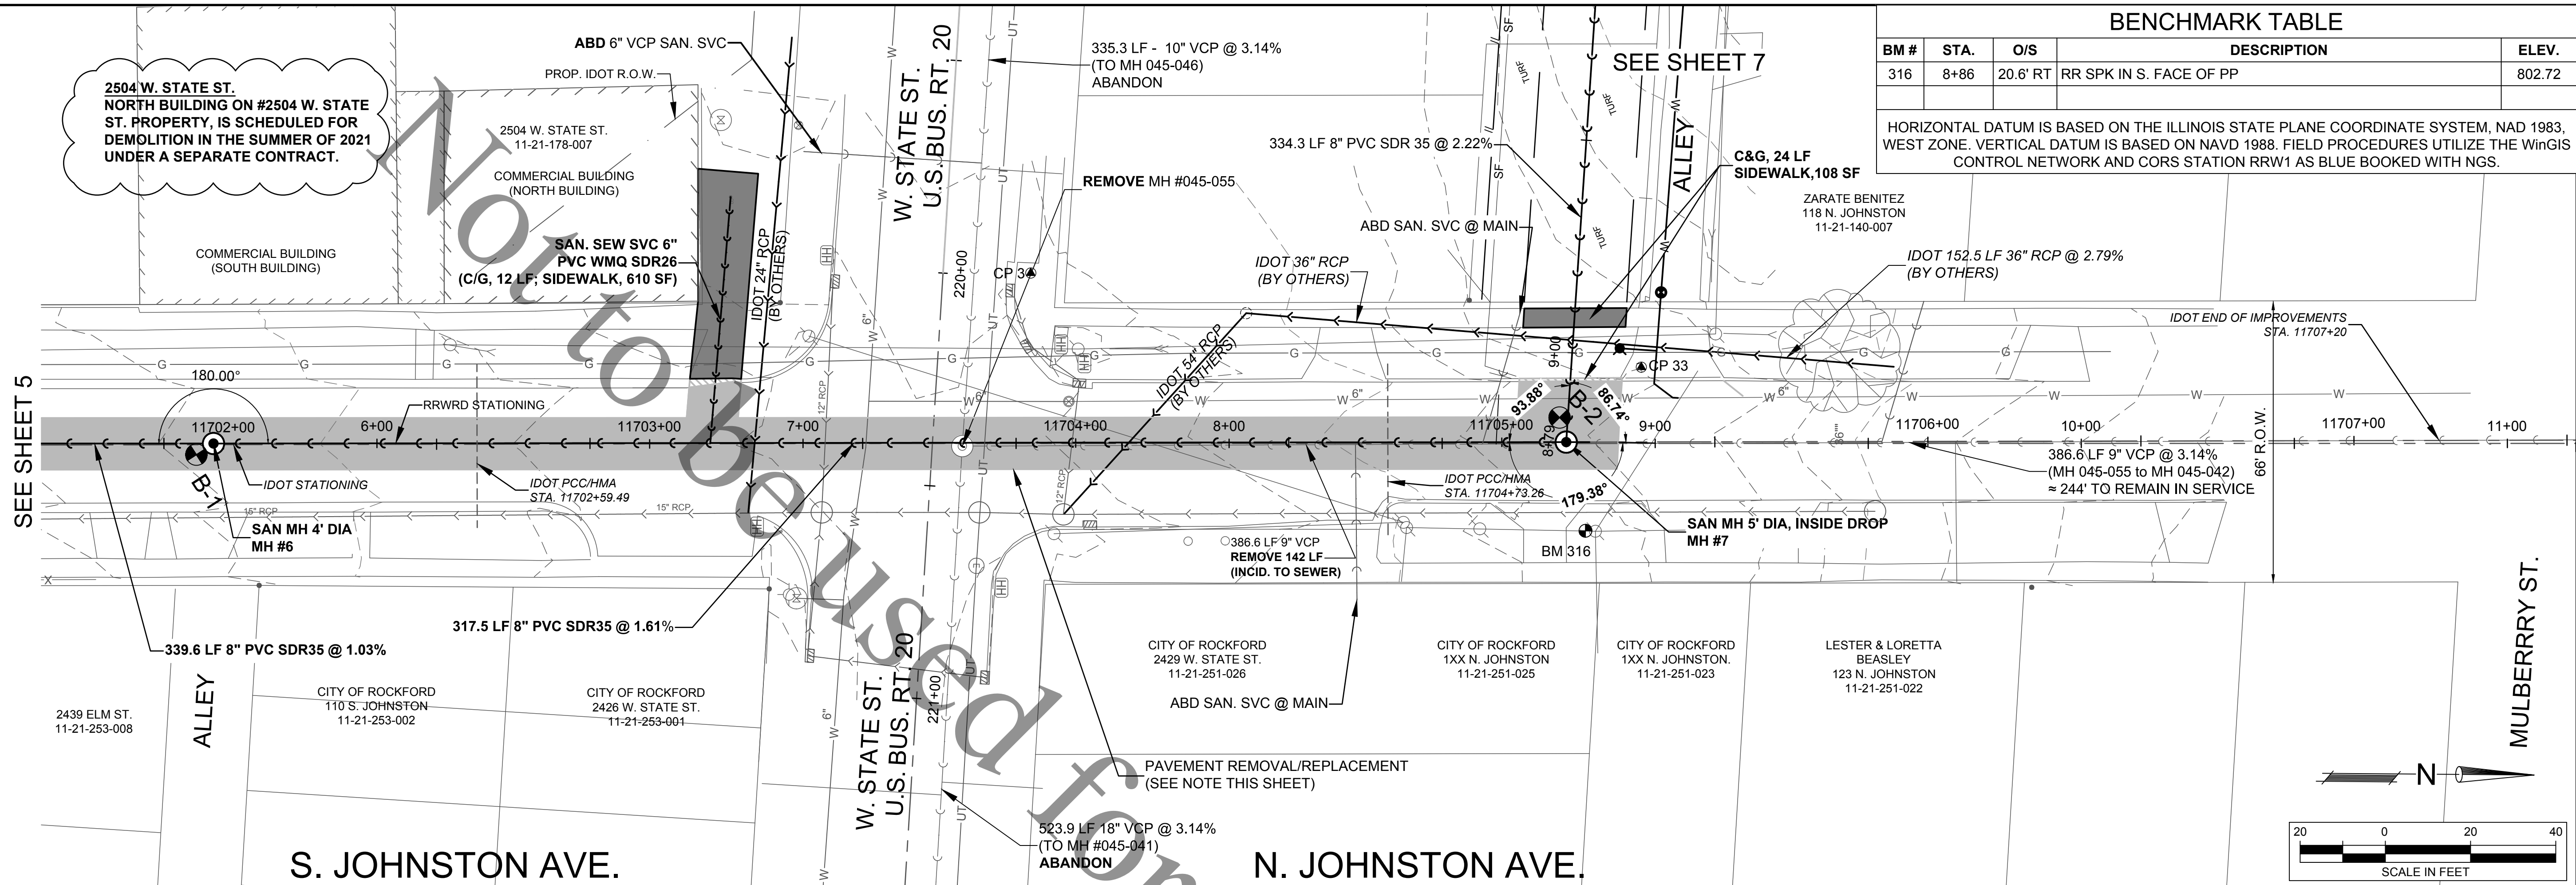

**ROCK RIVER WATER
RECLAMATION DISTRICT**
3501 KISHWAUKEE STREET
ROCKFORD, ILLINOIS 61109
(815) 387-7660

No.	DATE	REVISION	INT.

**WEST STATE STREET SANITARY SEWER
CAPITAL IMPROVEMENT PROJECT NO. 2014**


N. JOHNSTON AVE

FOR BID

Sheet No.
6 OF 15

Date
6/2/2021

file: I:\District Projects\W State St Ph 2-2019 Sewer Rehab 0814101 Design\Drawings\C3D Working\2019 W State\W State 2019.dwg


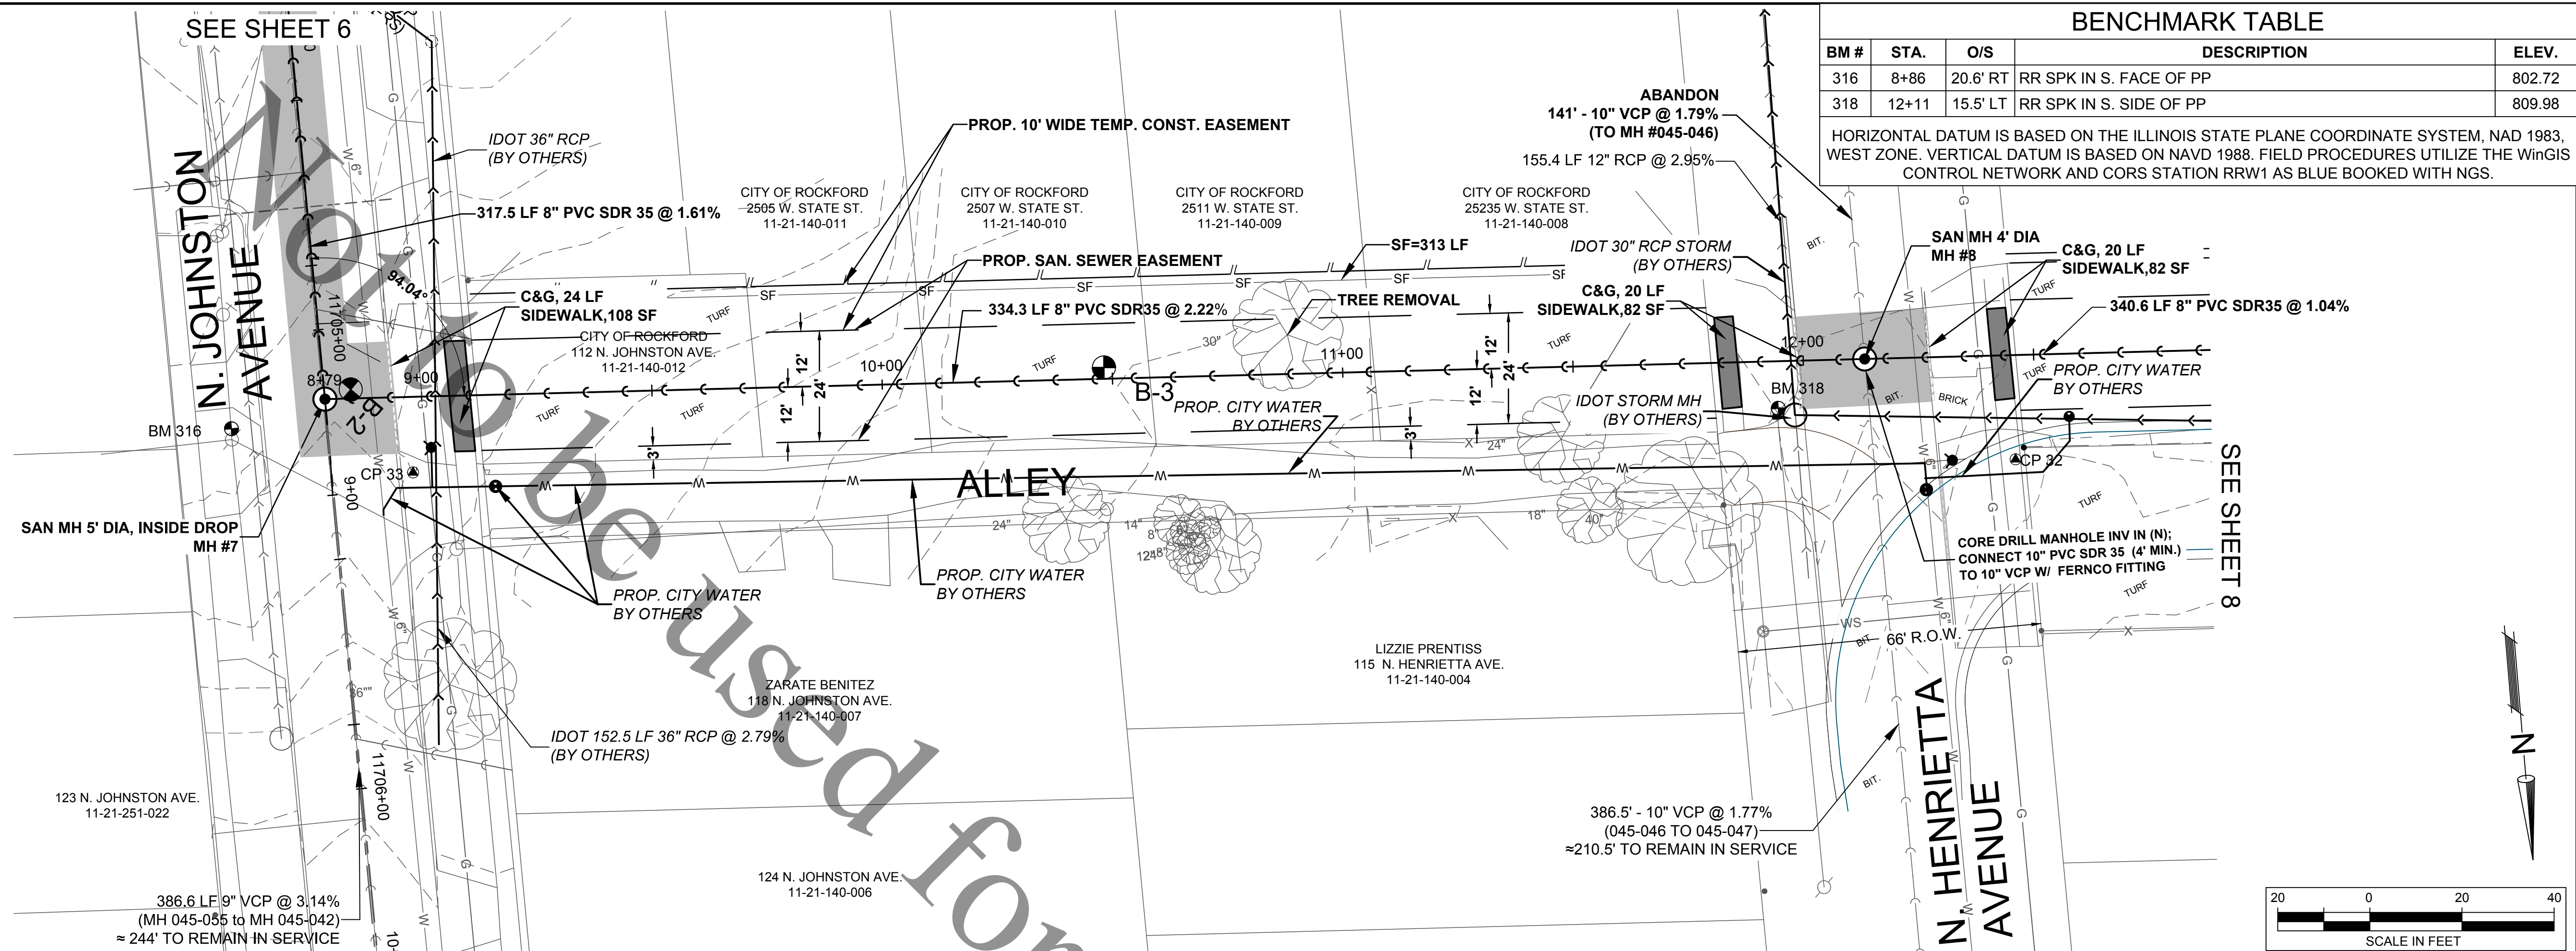


file: I:\District Projects\W State St Ph 2-2019 Sewer Rehab\081401 Design\Drawings\C3D Working\2019 W State\W State 2019.dwg

BENCHMARK TABLE

BM #	STA.	O/S	DESCRIPTION	ELEV.
318	12+11	15.5' LT	RR SPK IN S. SIDE OF PP	809.98
321	16+07	72' RT	RR SPK IN PP ON EAST SIDE	815.22

HORIZONTAL DATUM IS BASED ON THE ILLINOIS STATE PLANE COORDINATE SYSTEM, NAD 1983, WEST ZONE. VERTICAL DATUM IS BASED ON NAVD 1988. FIELD PROCEDURES UTILIZE THE WinGIS CONTROL NETWORK AND CORS STATION RRW1 AS BLUE BOOKED WITH NGS.

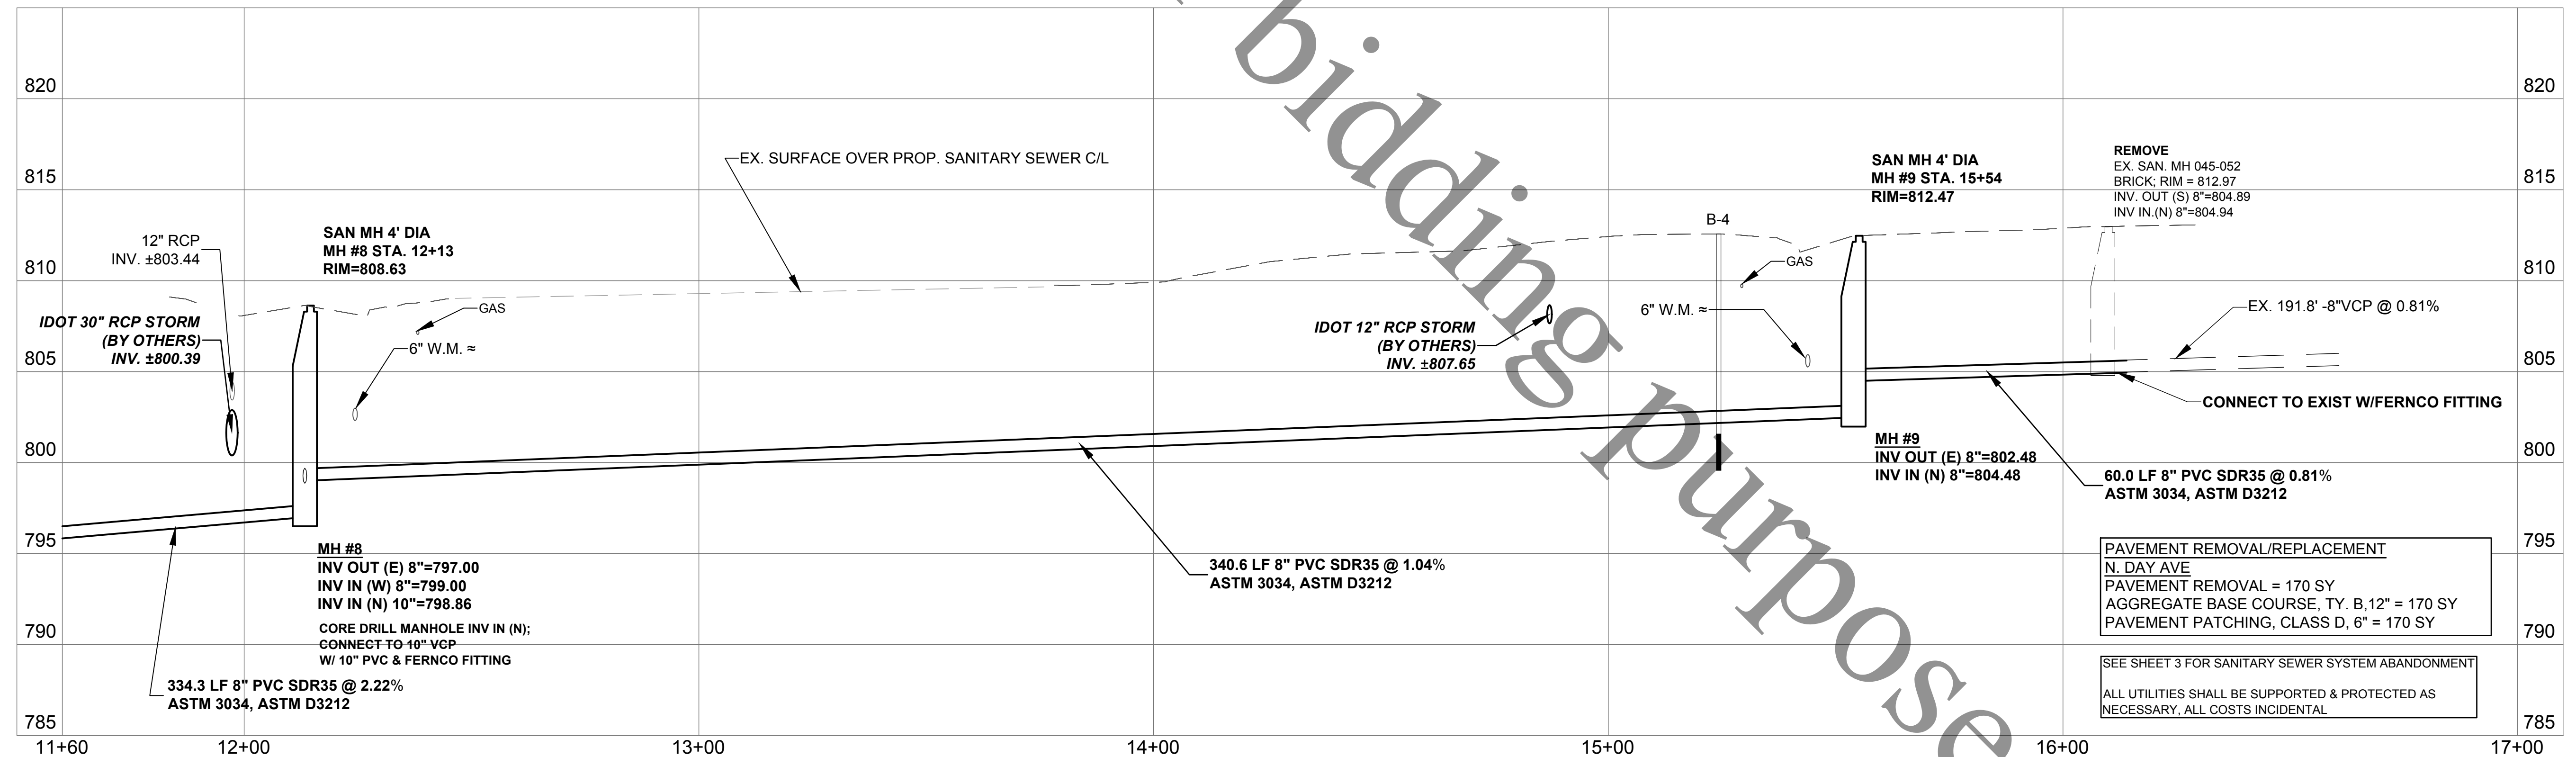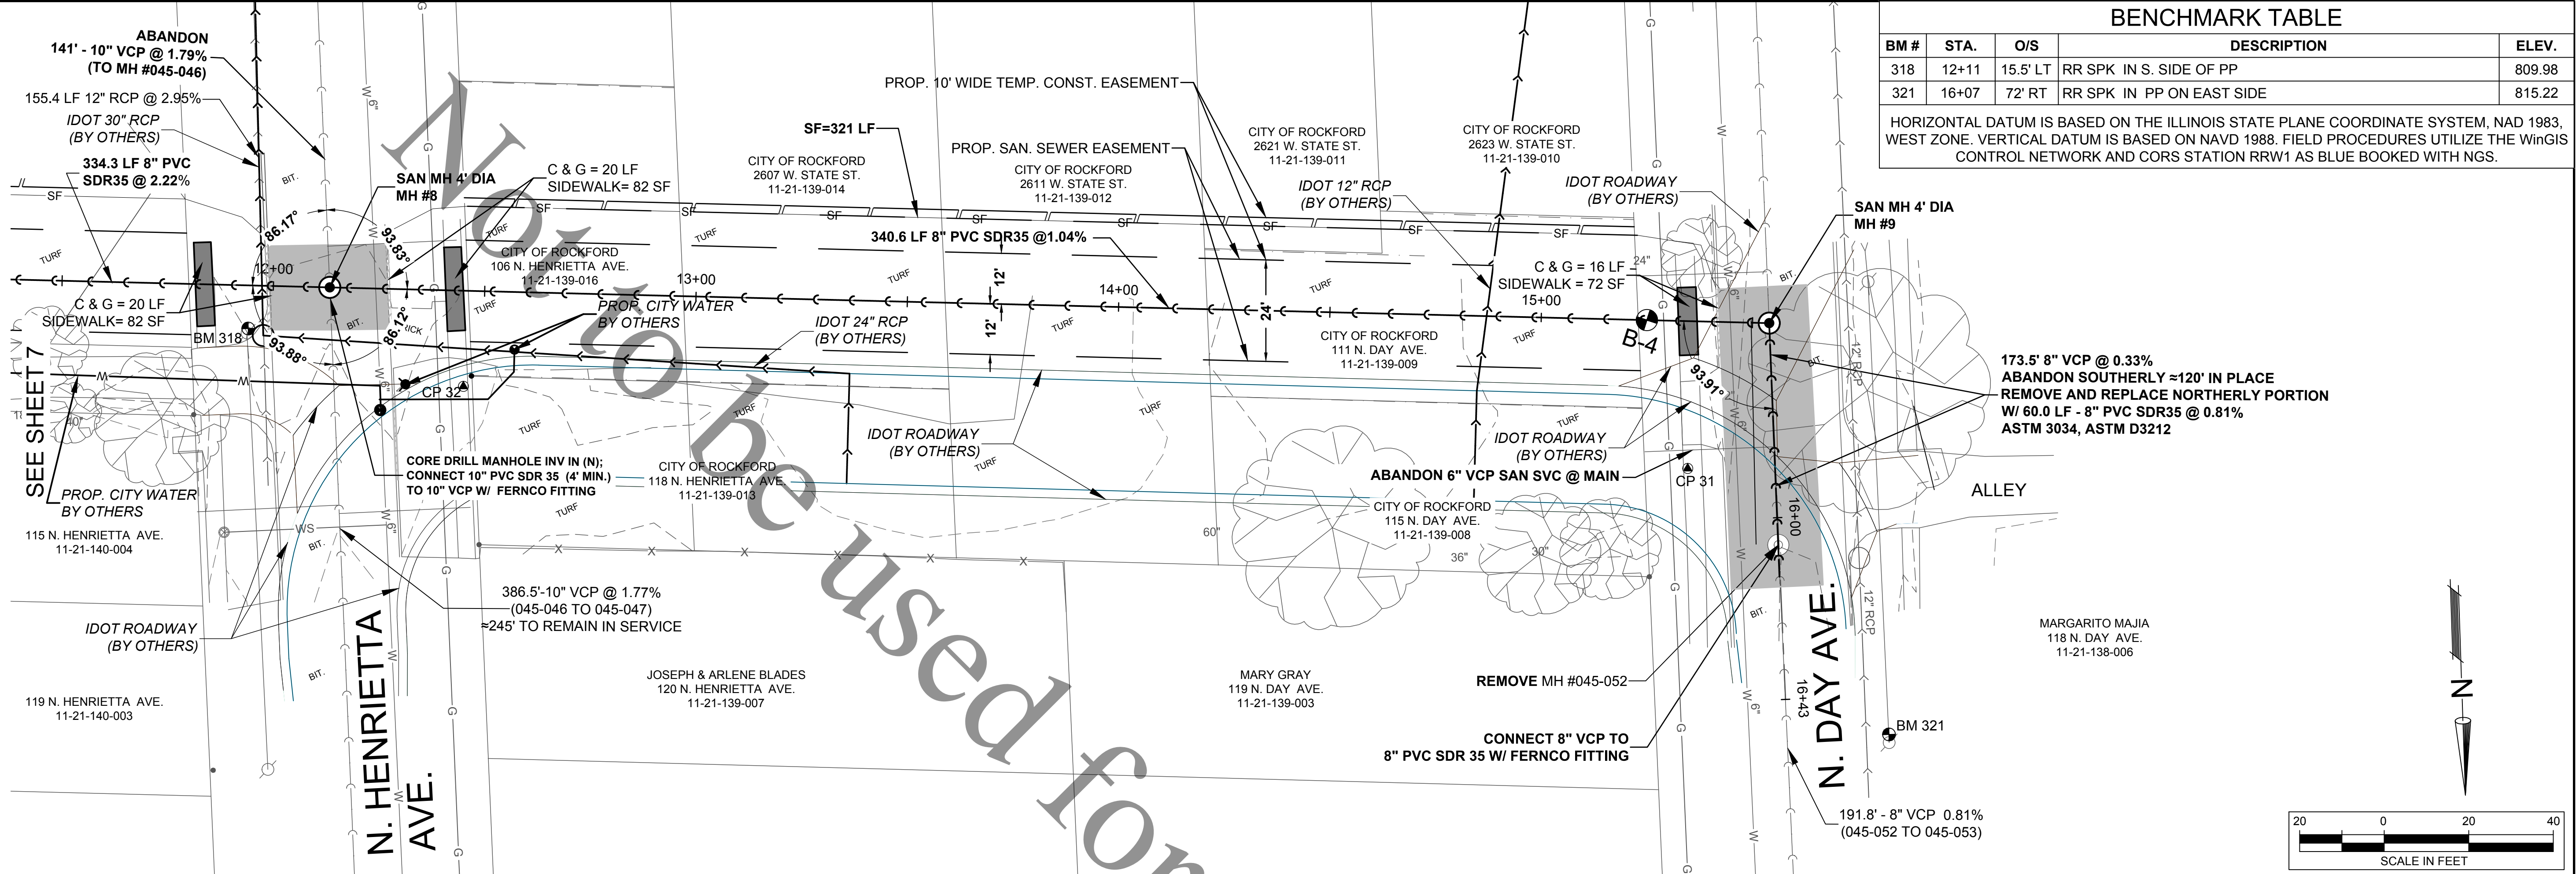

ROCK RIVER WATER
RECLAMATION DISTRICT
3501 KISHWAUKEE STREET
ROCKFORD, ILLINOIS 61109
(815) 387-7660

No.	DATE	REVISION	INT.

WEST STATE STREET SANITARY SEWER
CAPITAL IMPROVEMENT PROJECT NO. 2014


HENRIETTA - N. DAY AVE

Sheet No.
8 OF 15



Date
6/2/2021

FOR BID

file: I:\District Projects\W State St Ph 2-2019 Sewer Rehab 0814101 Design\Drawings\C3D Working\2019 W State\W State 2019.dwg

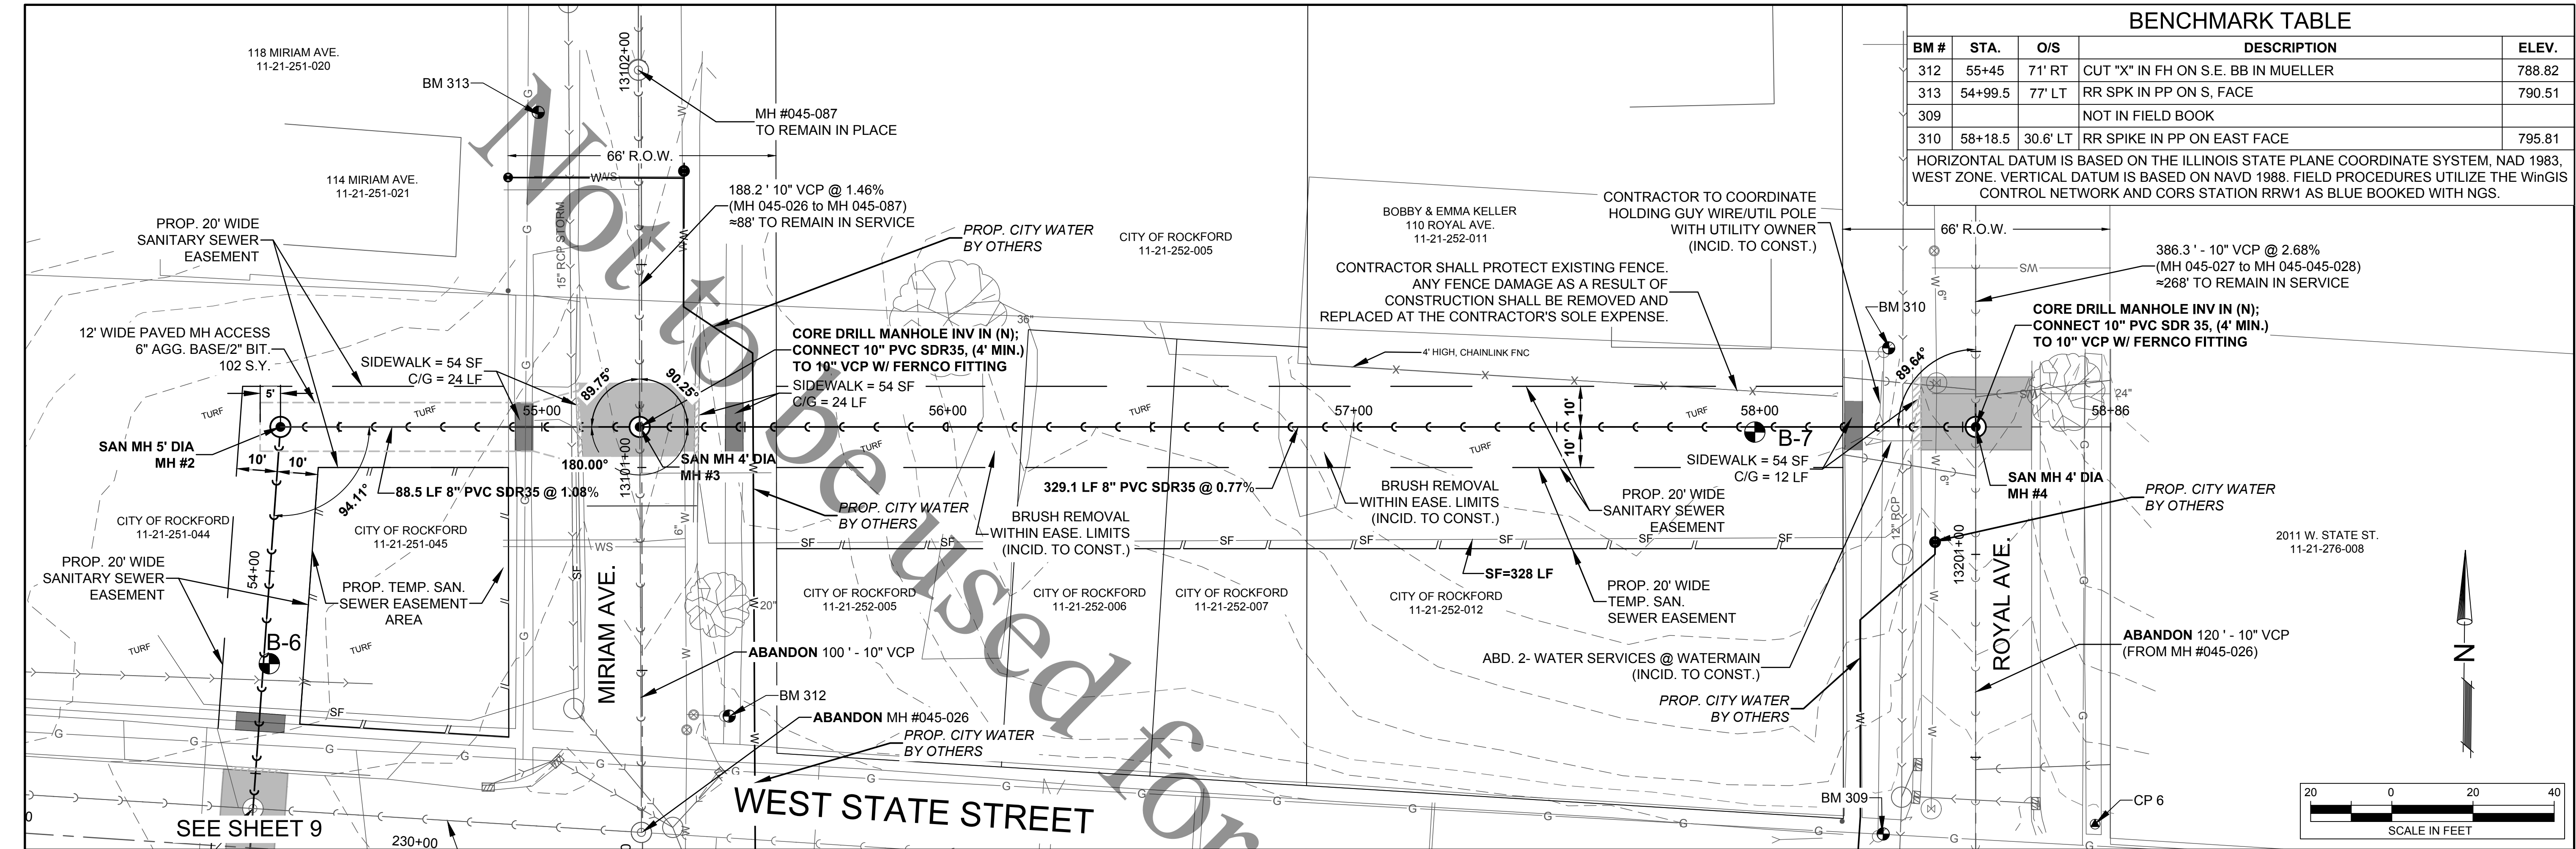


BENCHMARK TABLE				
BM #	STA.	O/S	DESCRIPTION	ELEV.
312	55+45	71' RT	CUT "X" IN FH ON S.E. BB IN MUELLER	788.82
313	54+99.5	77' LT	RR SPK IN PP ON S. FACE	790.51
309			NOT IN FIELD BOOK	
310	58+18.5	30.6' LT	RR SPIKE IN PP ON EAST FACE	795.81
HORIZONTAL DATUM IS BASED ON THE ILLINOIS STATE PLANE COORDINATE SYSTEM, NAD 1983, WEST ZONE. VERTICAL DATUM IS BASED ON NAVD 1988. FIELD PROCEDURES UTILIZE THE WinGIS CONTROL NETWORK AND CORS STATION RRW1 AS BLUE BOOKED WITH NGS.				

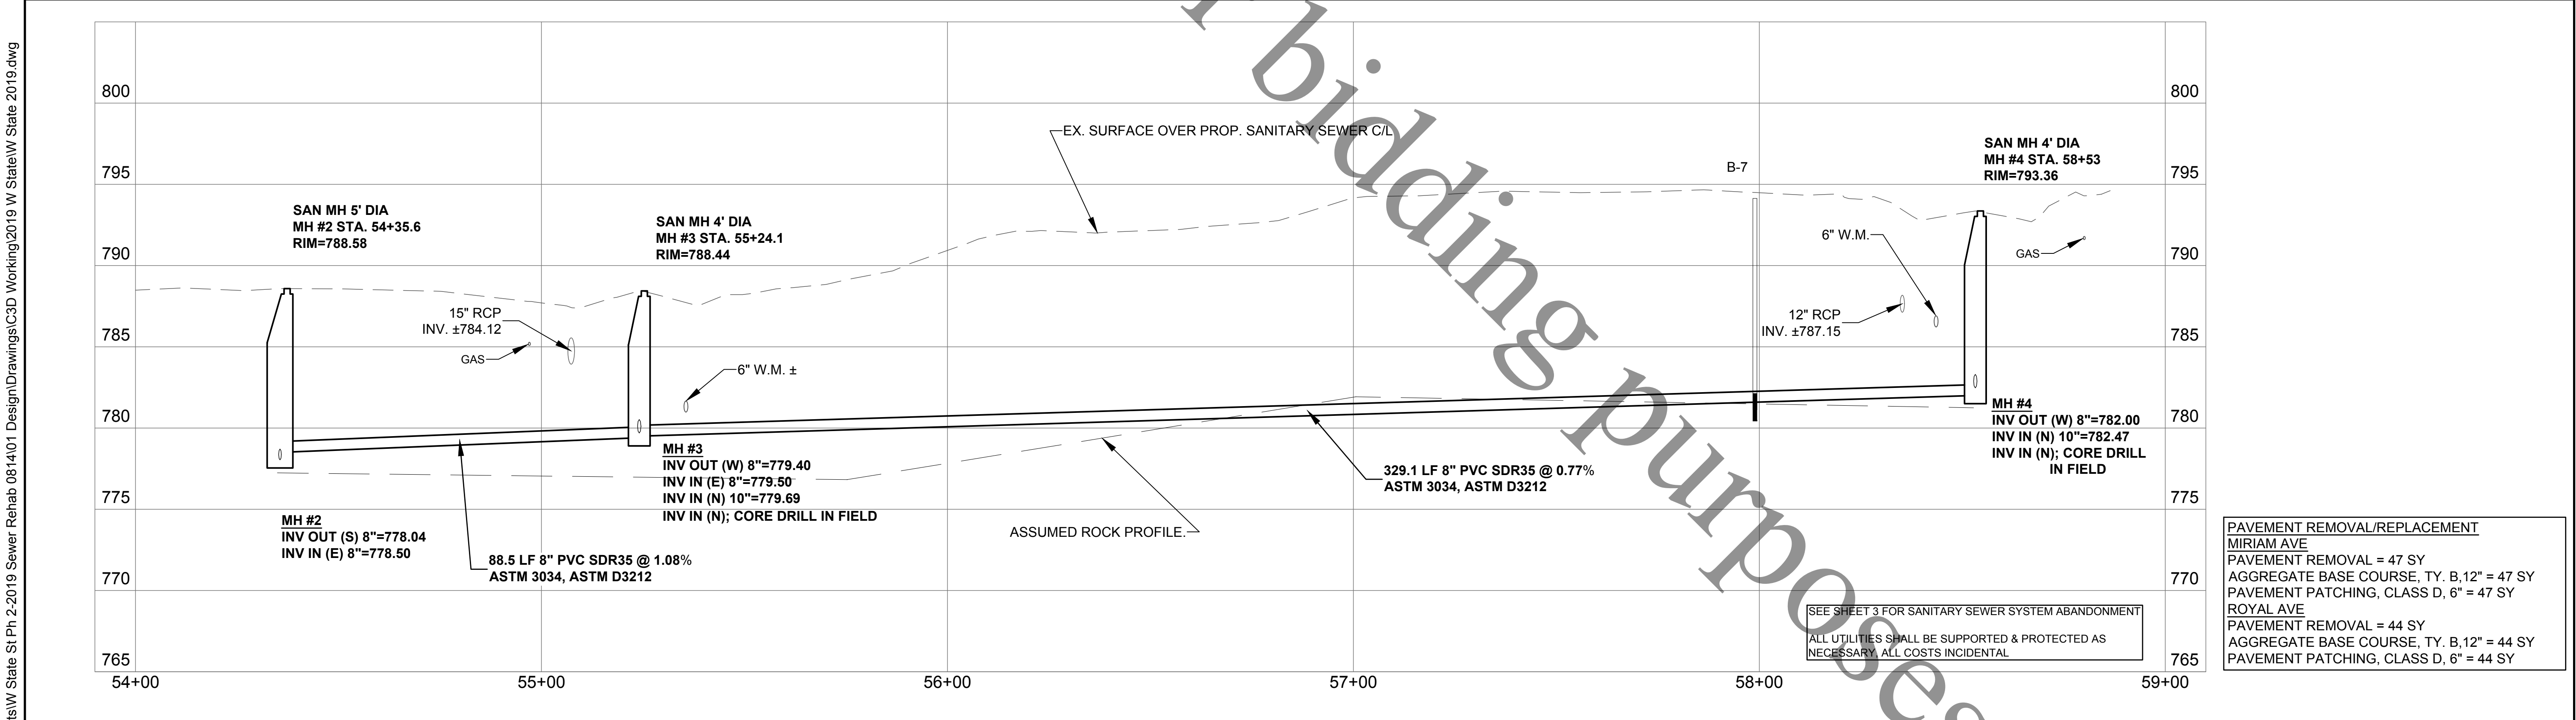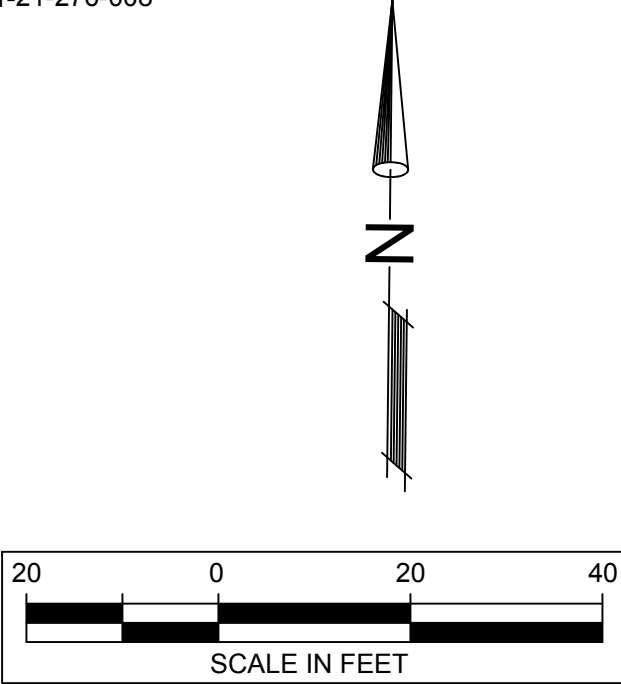

PAVEMENT REMOVAL/REPLACEMENT	
MIRIAM AVE	
PAVEMENT REMOVAL = 47 SY	
AGGREGATE BASE COURSE, TY. B, 12" = 47 SY	
PAVEMENT PATCHING, CLASS D, 6" = 47 SY	
ROYAL AVE	
PAVEMENT REMOVAL = 44 SY	
AGGREGATE BASE COURSE, TY. B, 12" = 44 SY	
PAVEMENT PATCHING, CLASS D, 6" = 44 SY	

file: I:\District Projects\W State St Ph 2-2019 Sewer Rehab 081401 Design\Drawings\C3D Working\2019 W State\W State 2019.dwg

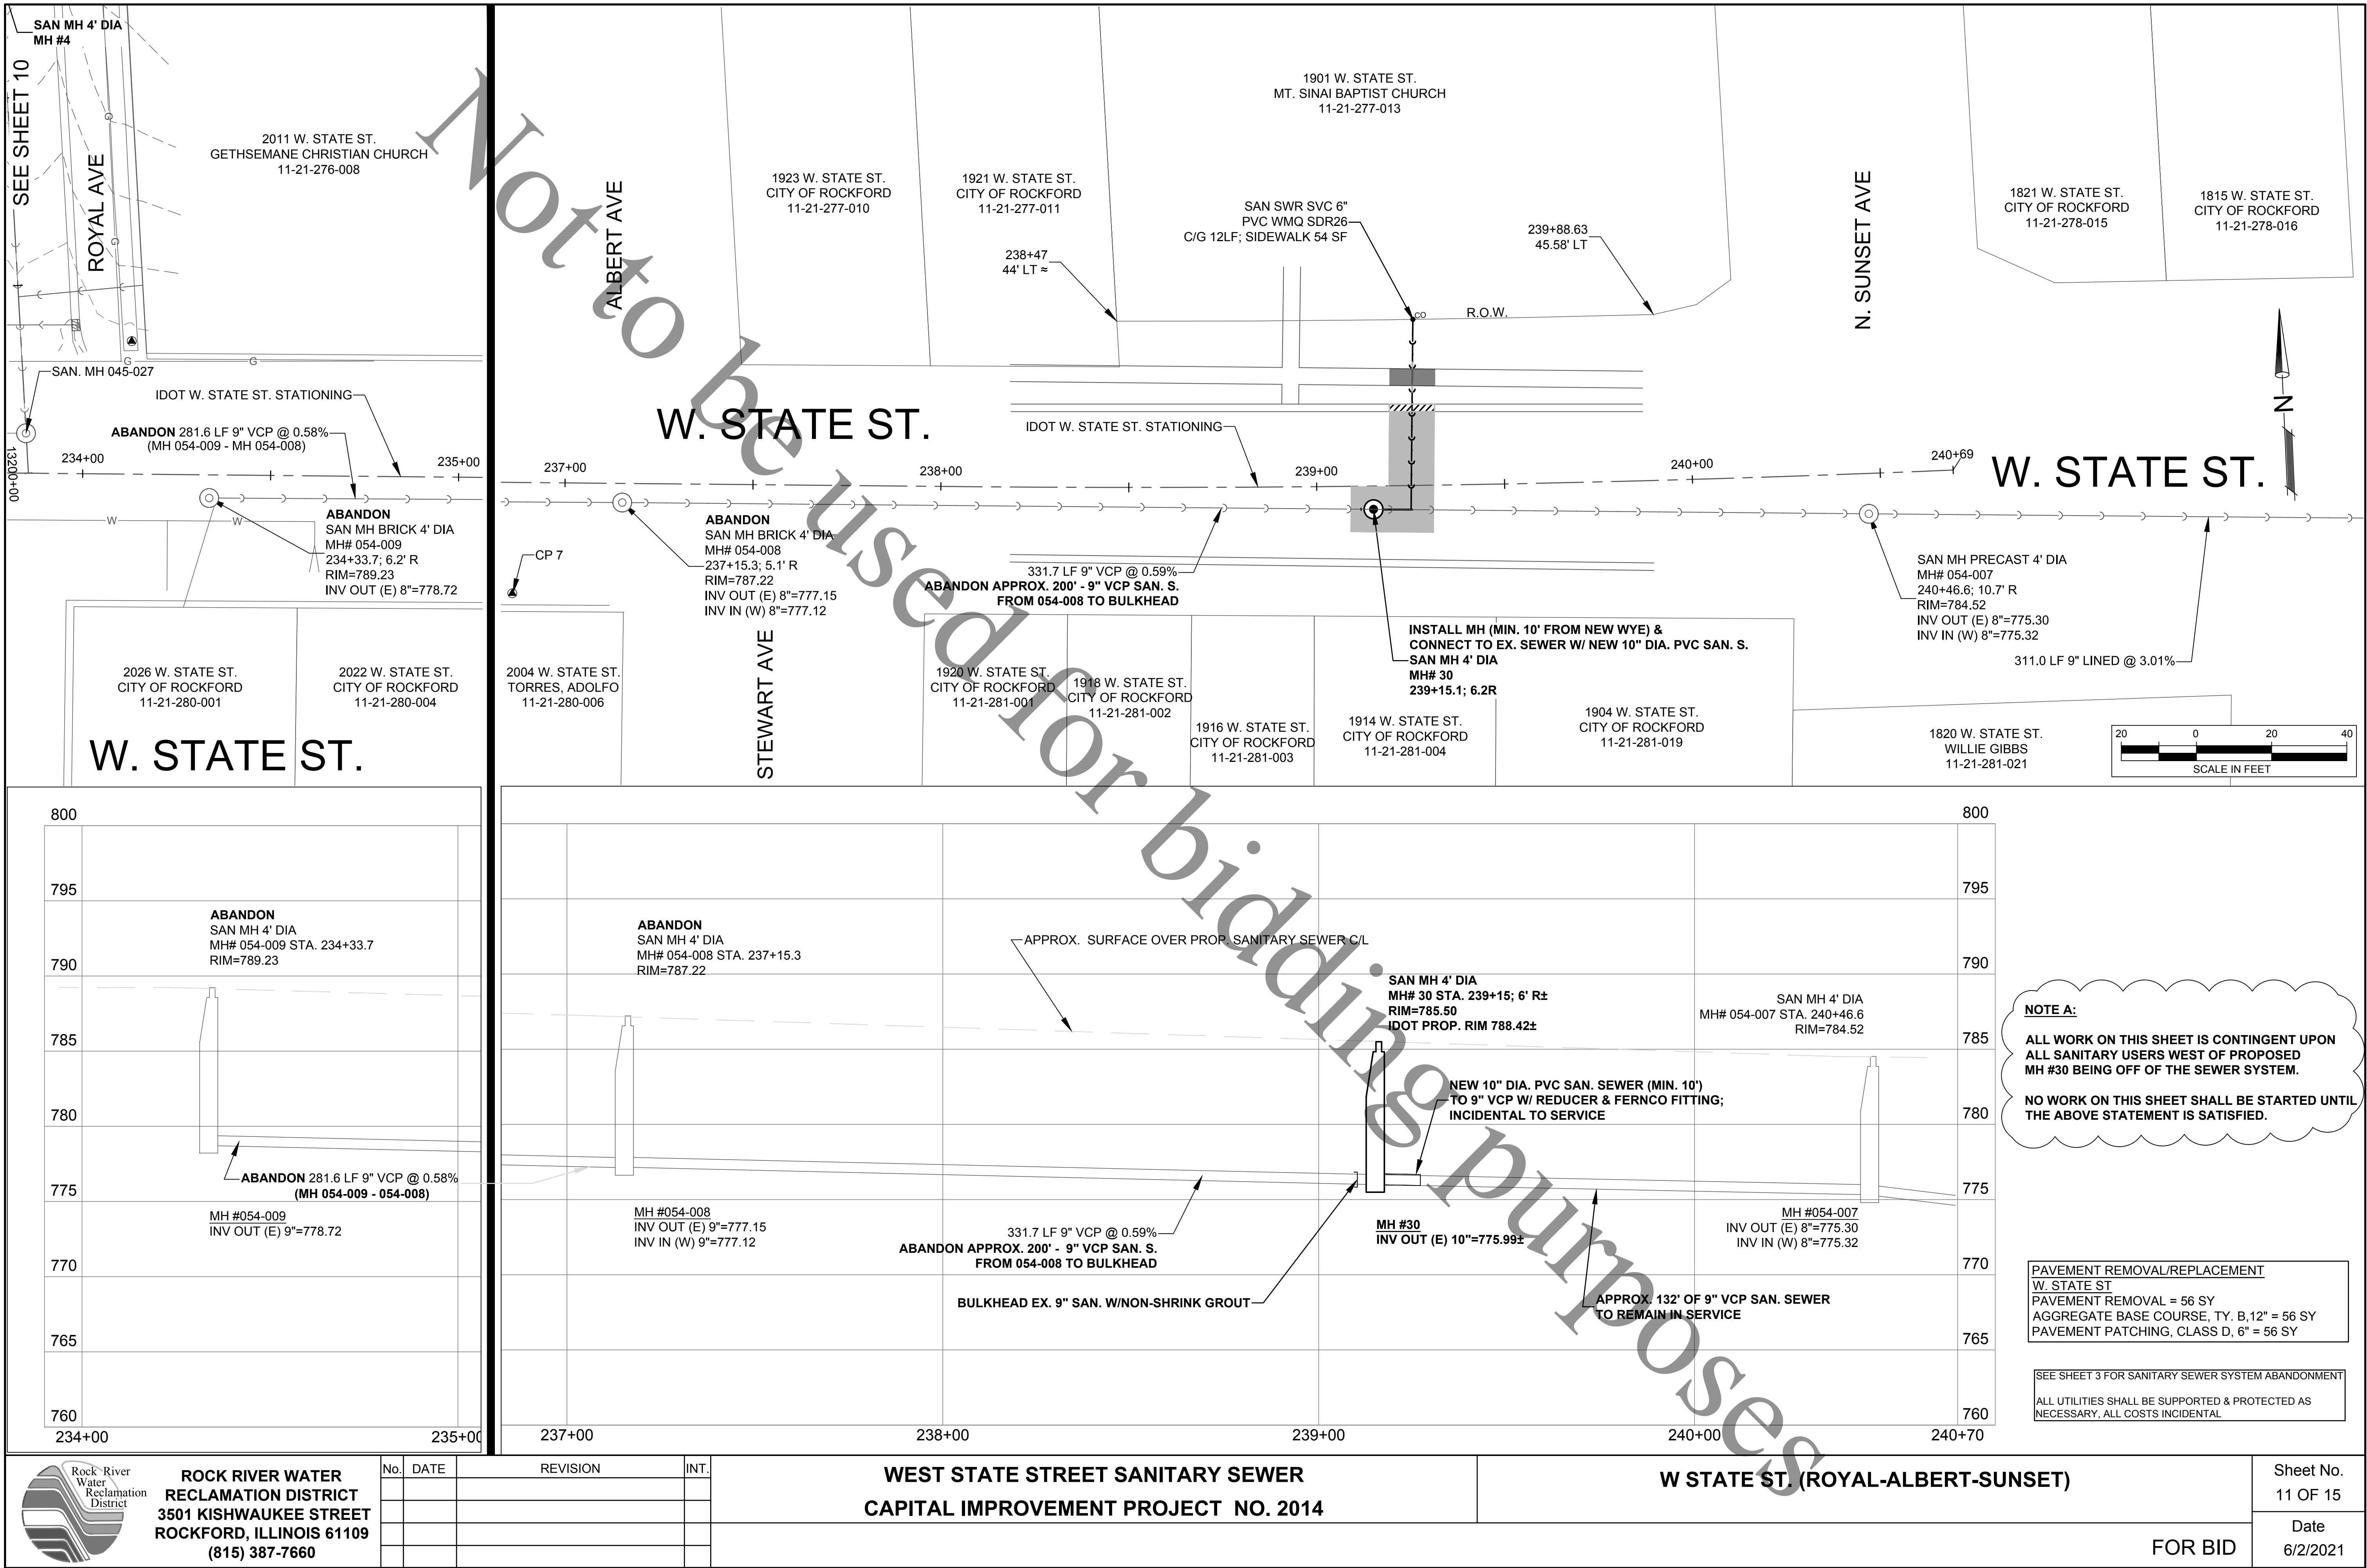

file: I:\District Projects\W State St Ph 2-2019 Sewer Rehab 081401 Design\Drawings\C3D Working\2019 W StateW State 2019.dwg

FILE NAME = D264H08-shr-staging-detour.dgn



LEGEND

- 1 SIGN ON PORTABLE OR PERMANENT SUPPORT
- 2 TYPE III BARRICADE WITH FLASHERS
- 3 WORK AREA
- 4 DETOUR ROUTE

NOTES:

- US ROUTE 20 SHALL BE CLOSED TO TRAFFIC AT ALL TIMES FROM DAY AVENUE TO CENTRAL AVENUE FOR THE DURATION OF CONSTRUCTION.
- CONSTRUCTION SHALL BE STAGED TO MAINTAIN PEDESTRIAN ACCESS WITHIN THE PROJECT LIMITS FOR THE DURATION OF CONSTRUCTION.
-
- ALL SIGNING AND TRAFFIC CONTROL SHALL CONFORM TO DISTRICT 2 STANDARD 40.1.

• NO WORK SHALL BE PERFORMED WITHIN ILLINOIS DEPARTMENT OF TRANSPORTATION (IDOT) RIGHT-OF-WAY UNTIL THE DETOUR DETAILED IN THESE PLANS IS ESTABLISHED. THROUGH COLLABORATION WITH IDOT, THE RRWR HAS ARRANGED FOR THE DETOUR OF WEST STATE STREET TO BE ESTABLISHED UNDER SEPARATE CONTRACT. THE DETOUR WILL BE ESTABLISHED ON OR ABOUT AUGUST 15, AND REMAIN IN PLACE FOR SIXTY (60) CALENDAR DAYS TO ALLOW FOR UTILITY WORK, INCLUDING THIS SANITARY SEWER CONTRACT. ANY ADDITIONAL TRAFFIC CONTROL REQUIRED FOR STAGING, AS DETERMINED BY THE CONTRACTOR, SHALL BE HIS OR HER RESPONSIBILITY AT NO ADDITIONAL COST TO THE RRWR. TRAFFIC CONTROL FOR LOCAL STREETS REQUIRED OUTSIDE OF THE SIXTY CALENDAR DAYS PROVIDED FOR SHALL BE PAID AT THE CONTRACT LUMP SUM UNIT PRICE FOR TRAFFIC CONTROL AND PROTECTION, LOCAL STREETS. SHOULD THE CONTRACTOR REQUIRE MORE THAN SIXTY (60) CALENDAR DAYS FOR WORK WITHIN IDOT RIGHT-OF-WAY, IT SHALL BE THE CONTRACTOR'S RESPONSIBILITY TO PERMIT, ESTABLISH AND MAINTAIN TRAFFIC CONTROL WITHIN IDOT RIGHT-OF-WAY AT NO ADDITIONAL COST TO THE RRWR.

SIGN LEGEND

- 1 ROAD CLOSED AHEAD W20-3(0)-48
- 2 DETOUR AHEAD W20-2-48
- 3 ROAD CLOSED 500 FT W20-3(0)-48
- 4 BARRICADE AHEAD W21-1100(0)-48
- 5 M6-1R-2115
- 6 M6-1L-2115
- 7 M5-1R-2115
- 8 M5-1L-2115
- 9 M6-3-2115
- 10 M4-8-2412 EAST M3-2-2412 BUSINESS M4-3-2412 M1-40-2424
- 11 M4-8-2412 WEST M3-4-2412 BUSINESS M4-3-2412 M1-40-2424
- 12 END DETOUR M4-8A-2418
- 13 ROAD CLOSED TO THRU TRAFFIC R11-4-6030




USER NAME = EtzwileE	DESIGNED - CPK	REVISED -
DRAWN - MJM	REVIS	REVIS
PLOT SCALE = 1000.0000' / 1" =	CHECKED - MXF	REVIS
PLOT DATE = 3/12/2020	DATE - 03/02/2020	REVIS

STATE OF ILLINOIS
DEPARTMENT OF TRANSPORTATION

CONSTRUCTION STAGING AND TRAFFIC CONTROL
DETOUR PLAN

SCALE: NTS SHEET 1 OF 12 SHEETS STA. 197+50.00 TO STA. 263+50.00

F.A.P. RTE.	SECTION	COUNTY	TOTAL SHEETS	SHEET NO.
303	(40,41) R	WINNEBAGO	311	84
CONTRACT NO. 64H08				
ILLINOIS FED. AID PROJECT				

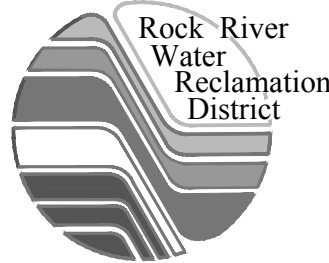

ROCK RIVER WATER
RECLAMATION DISTRICT
3501 KISHWAUKEE STREET
ROCKFORD, ILLINOIS 61109
(815) 387-7660

No.	DATE	REVISION	INT.

WEST STATE STREET SANITARY SEWER
CAPITAL IMPROVEMENT PROJECT NO. 2014


TRAFFIC CONTROL PLAN

Sheet No.
12 OF 15

Date
6/2/2021

FOR BID

TRAFFIC CONTROL FOR ROAD CLOSURE

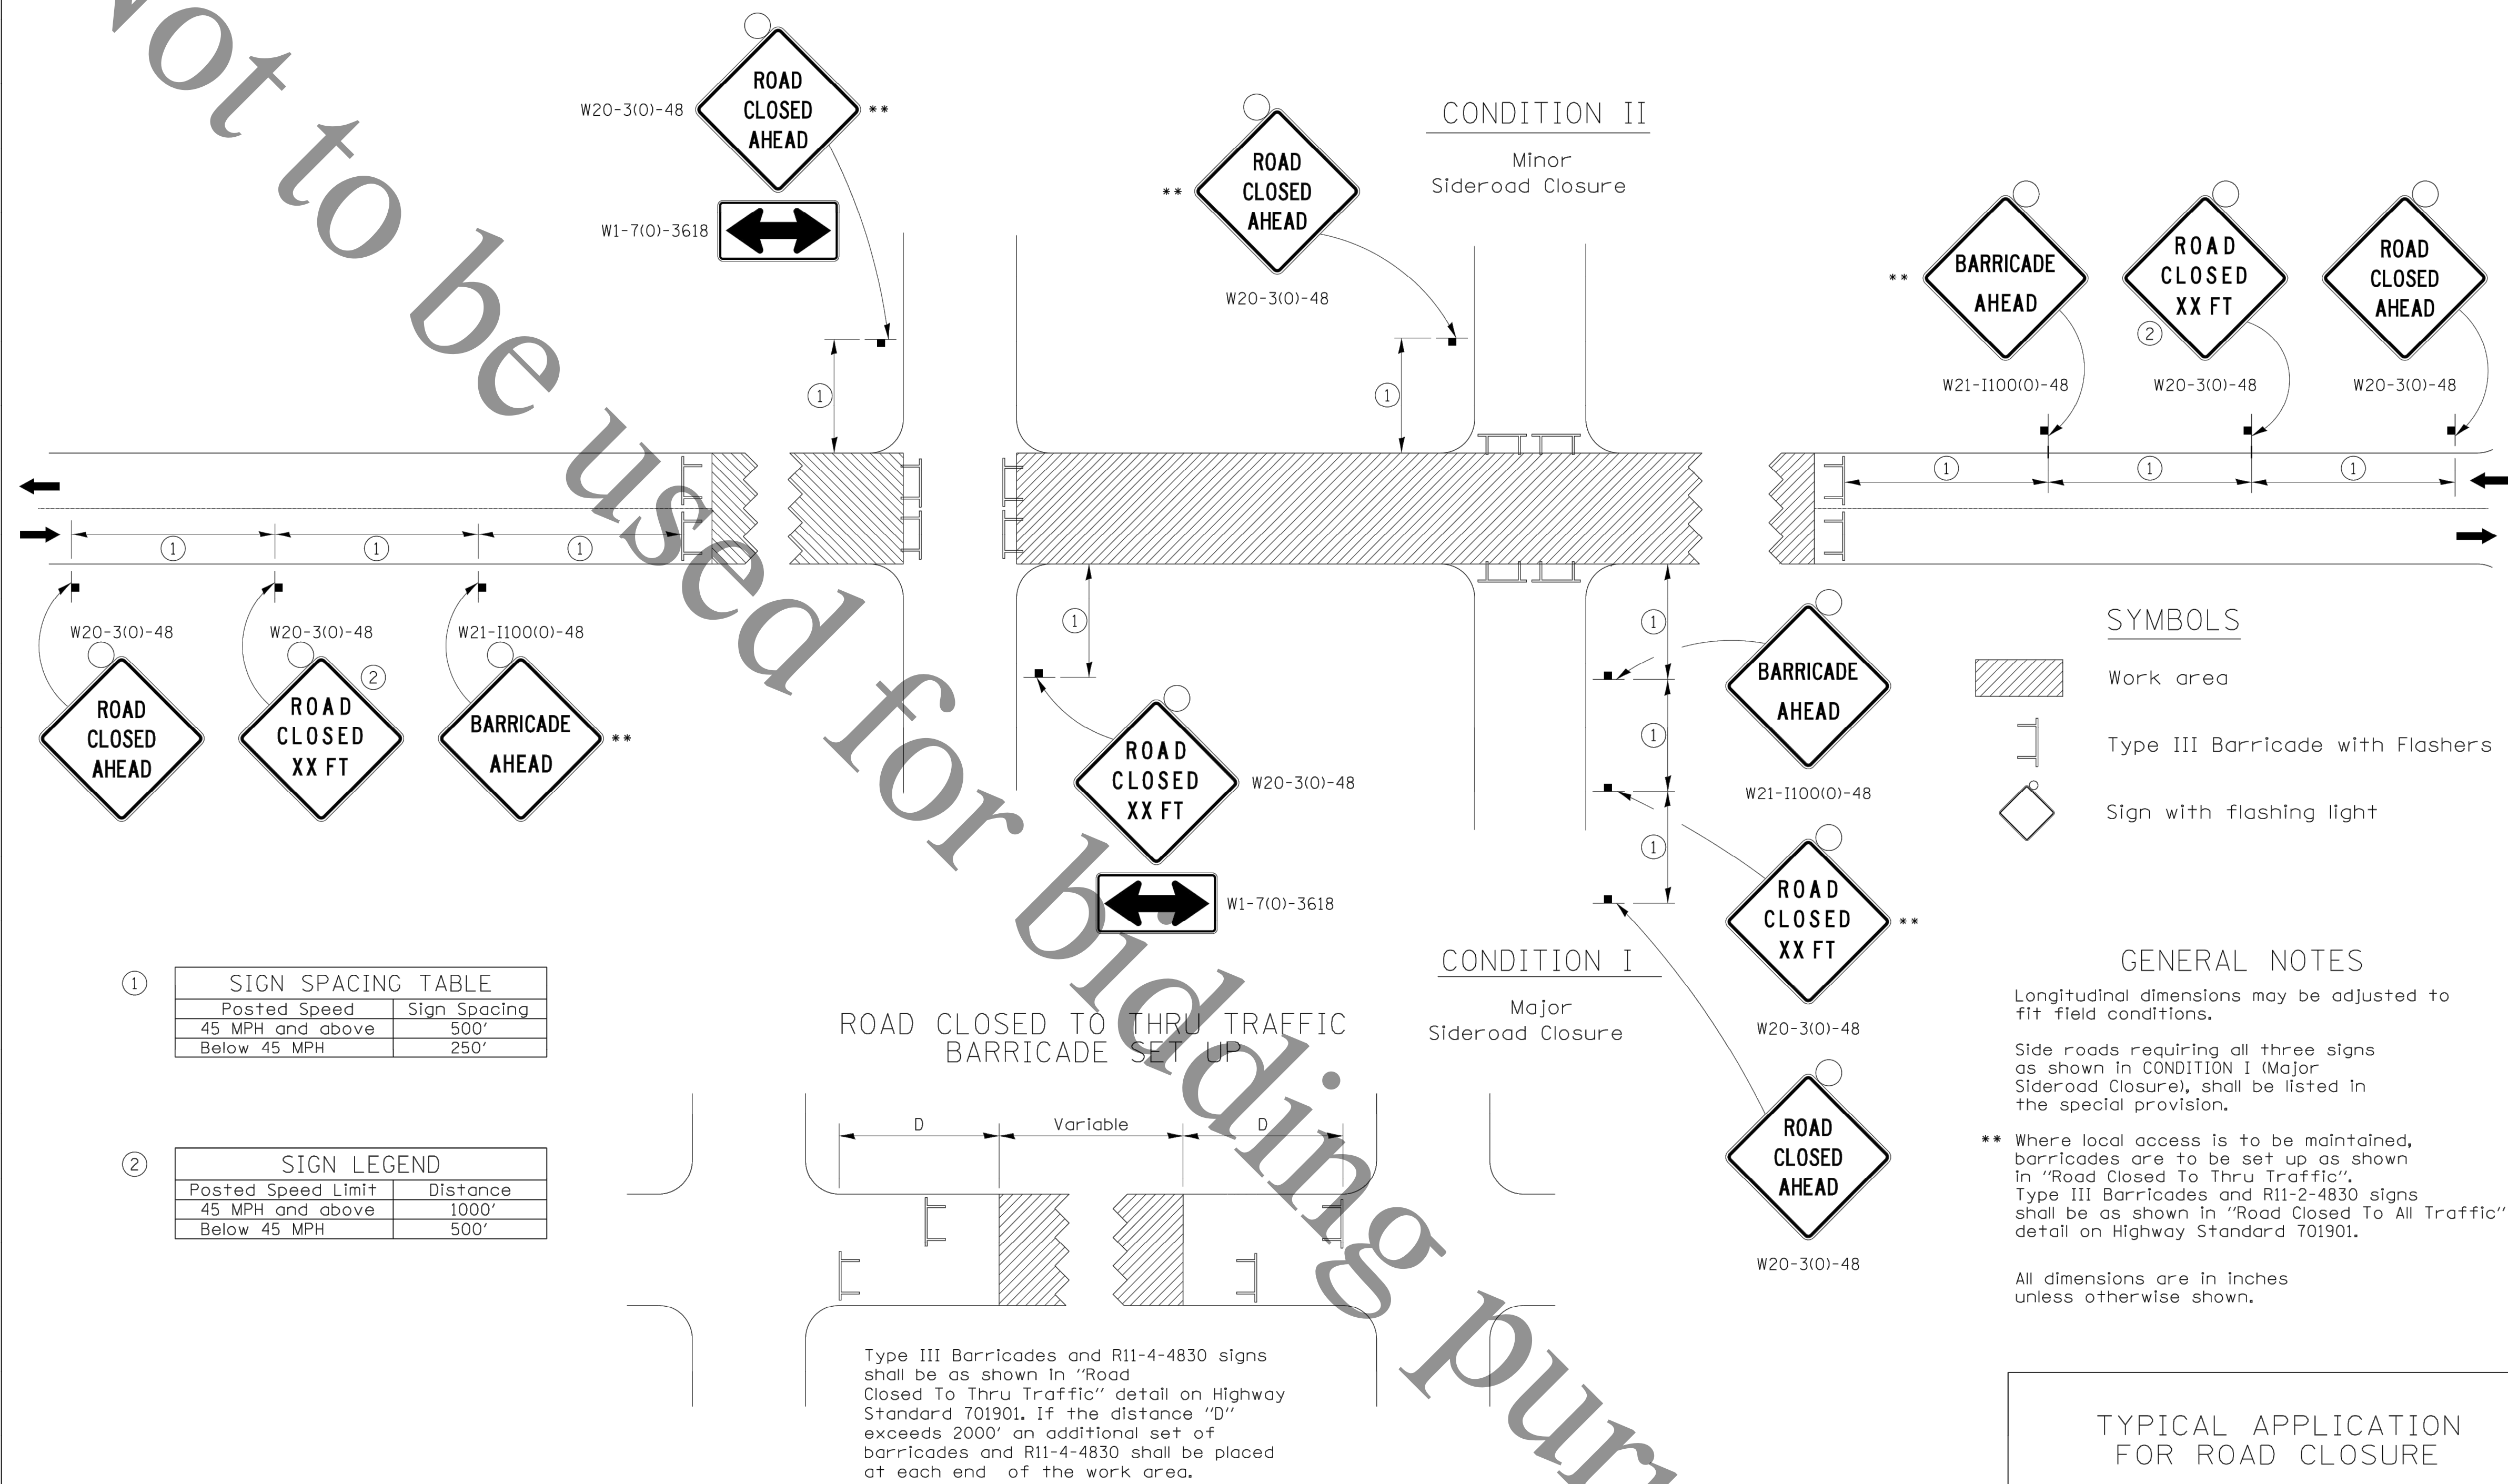

FILE NAME = District 2 Standard	USER NAME = IDOT/District 2	DESIGNED - DRAWN -	REVISED - 8-03-17 REVISED - 1-05-16	STATE OF ILLINOIS DEPARTMENT OF TRANSPORTATION	REGION 2 / DISTRICT 2 STANDARD			F.A. RTE.	SECTION	COUNTY	TOTAL SHEETS	SHEET NO.
	PLOT SCALE = 1/8" = 100'	CHECKED -	REVISED - 8-27-13		SCALE:	SHEET NO.	OF SHEETS	STA.	TO STA.	CONTRACT NO.		
	PLOT DATE = 1/10/2019	DATE -	REVISED - 10-17-11							FED. ROAD DIST. NO.	ILLINOIS FED. AID PROJECT	








ROCK RIVER WATER
RECLAMATION DISTRICT
3501 KISHWAUKEE STREET
ROCKFORD, ILLINOIS 61109
(815) 387-7660

No.	DATE	REVISION	INT.

WEST STATE STREET SANITARY SEWER
CAPITAL IMPROVEMENT PROJECT NO. 2014

DETAILS

file: I:\District Projects\W State St Ph 2-2019 Sewer Rehab 0814101 Design\Drawings\C3D Working\2019 W State\W State 2019.dwg

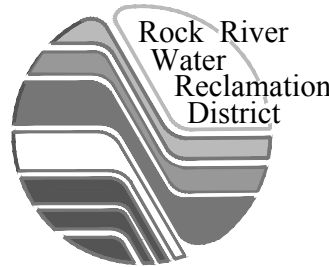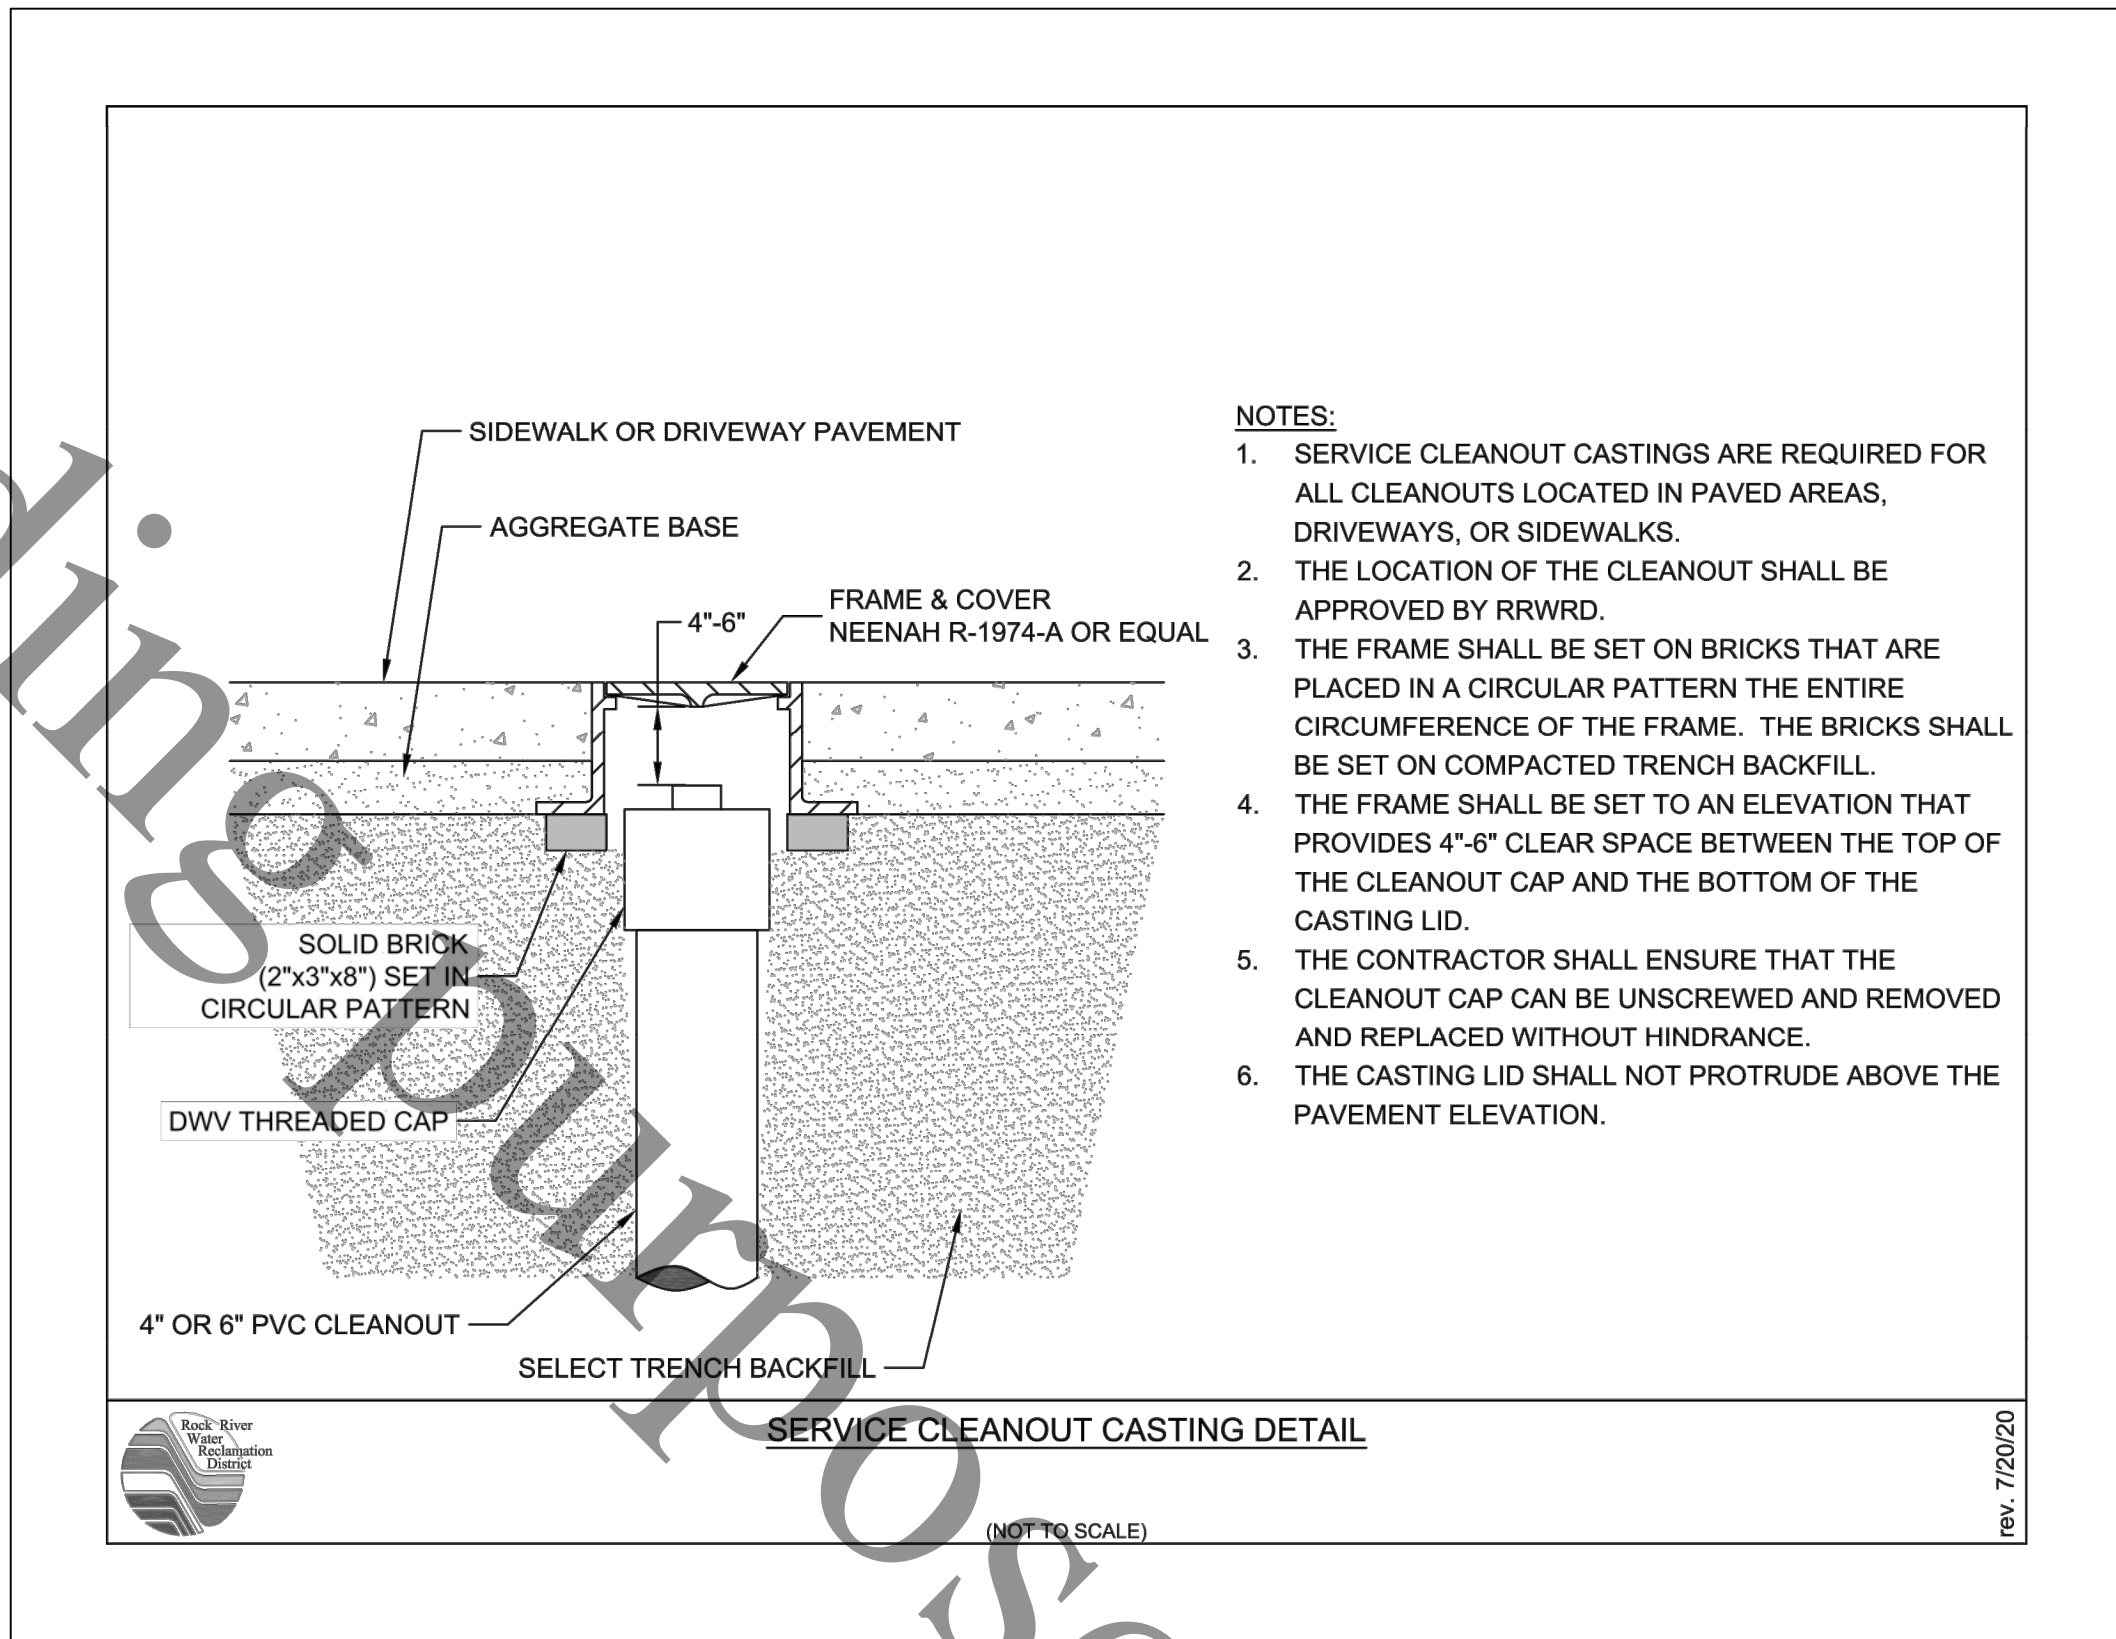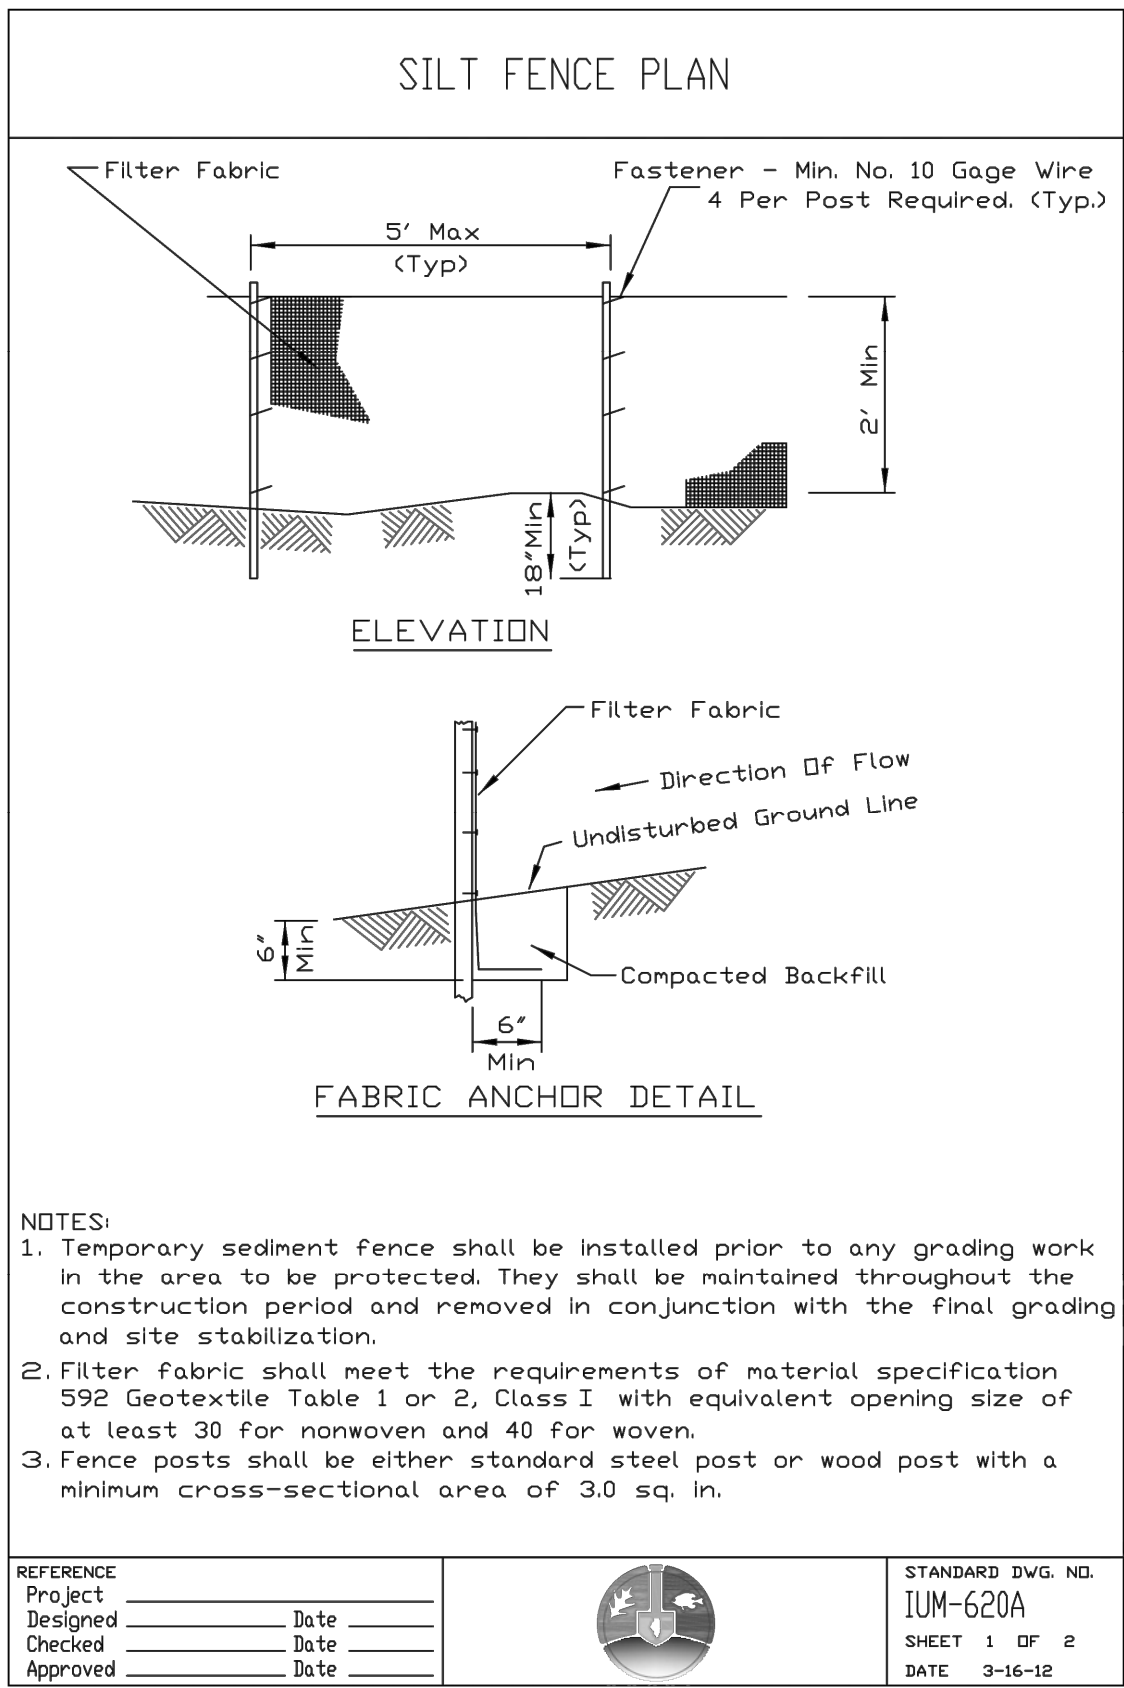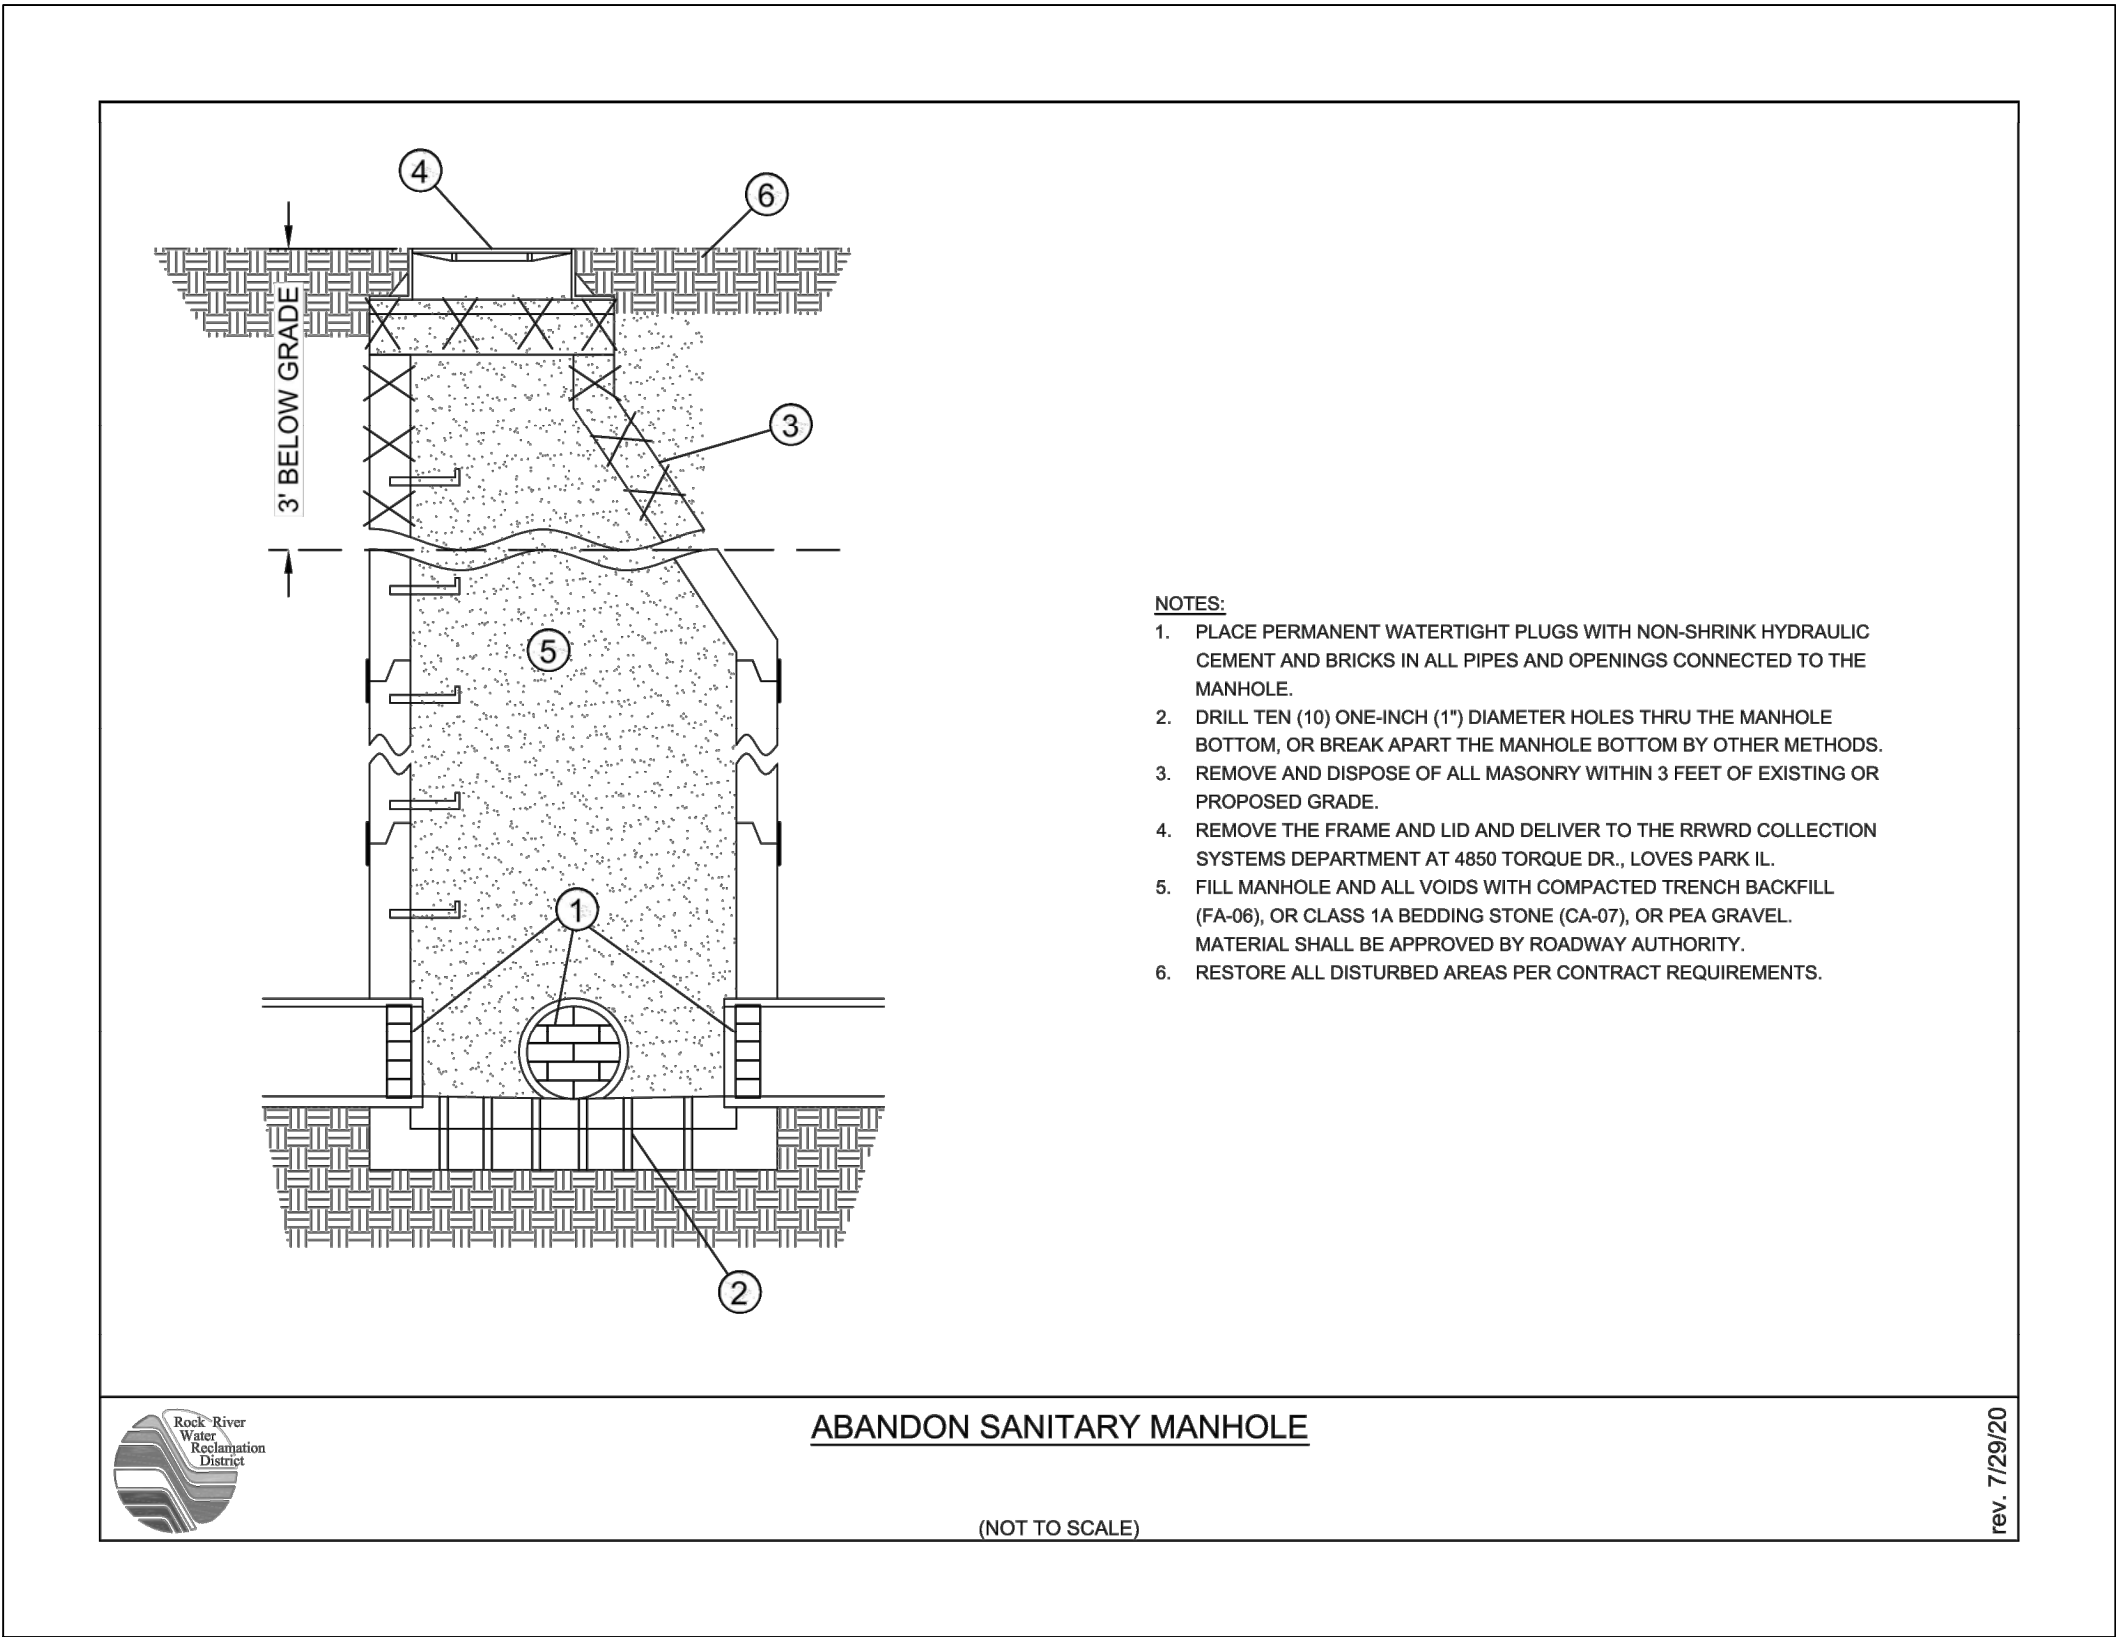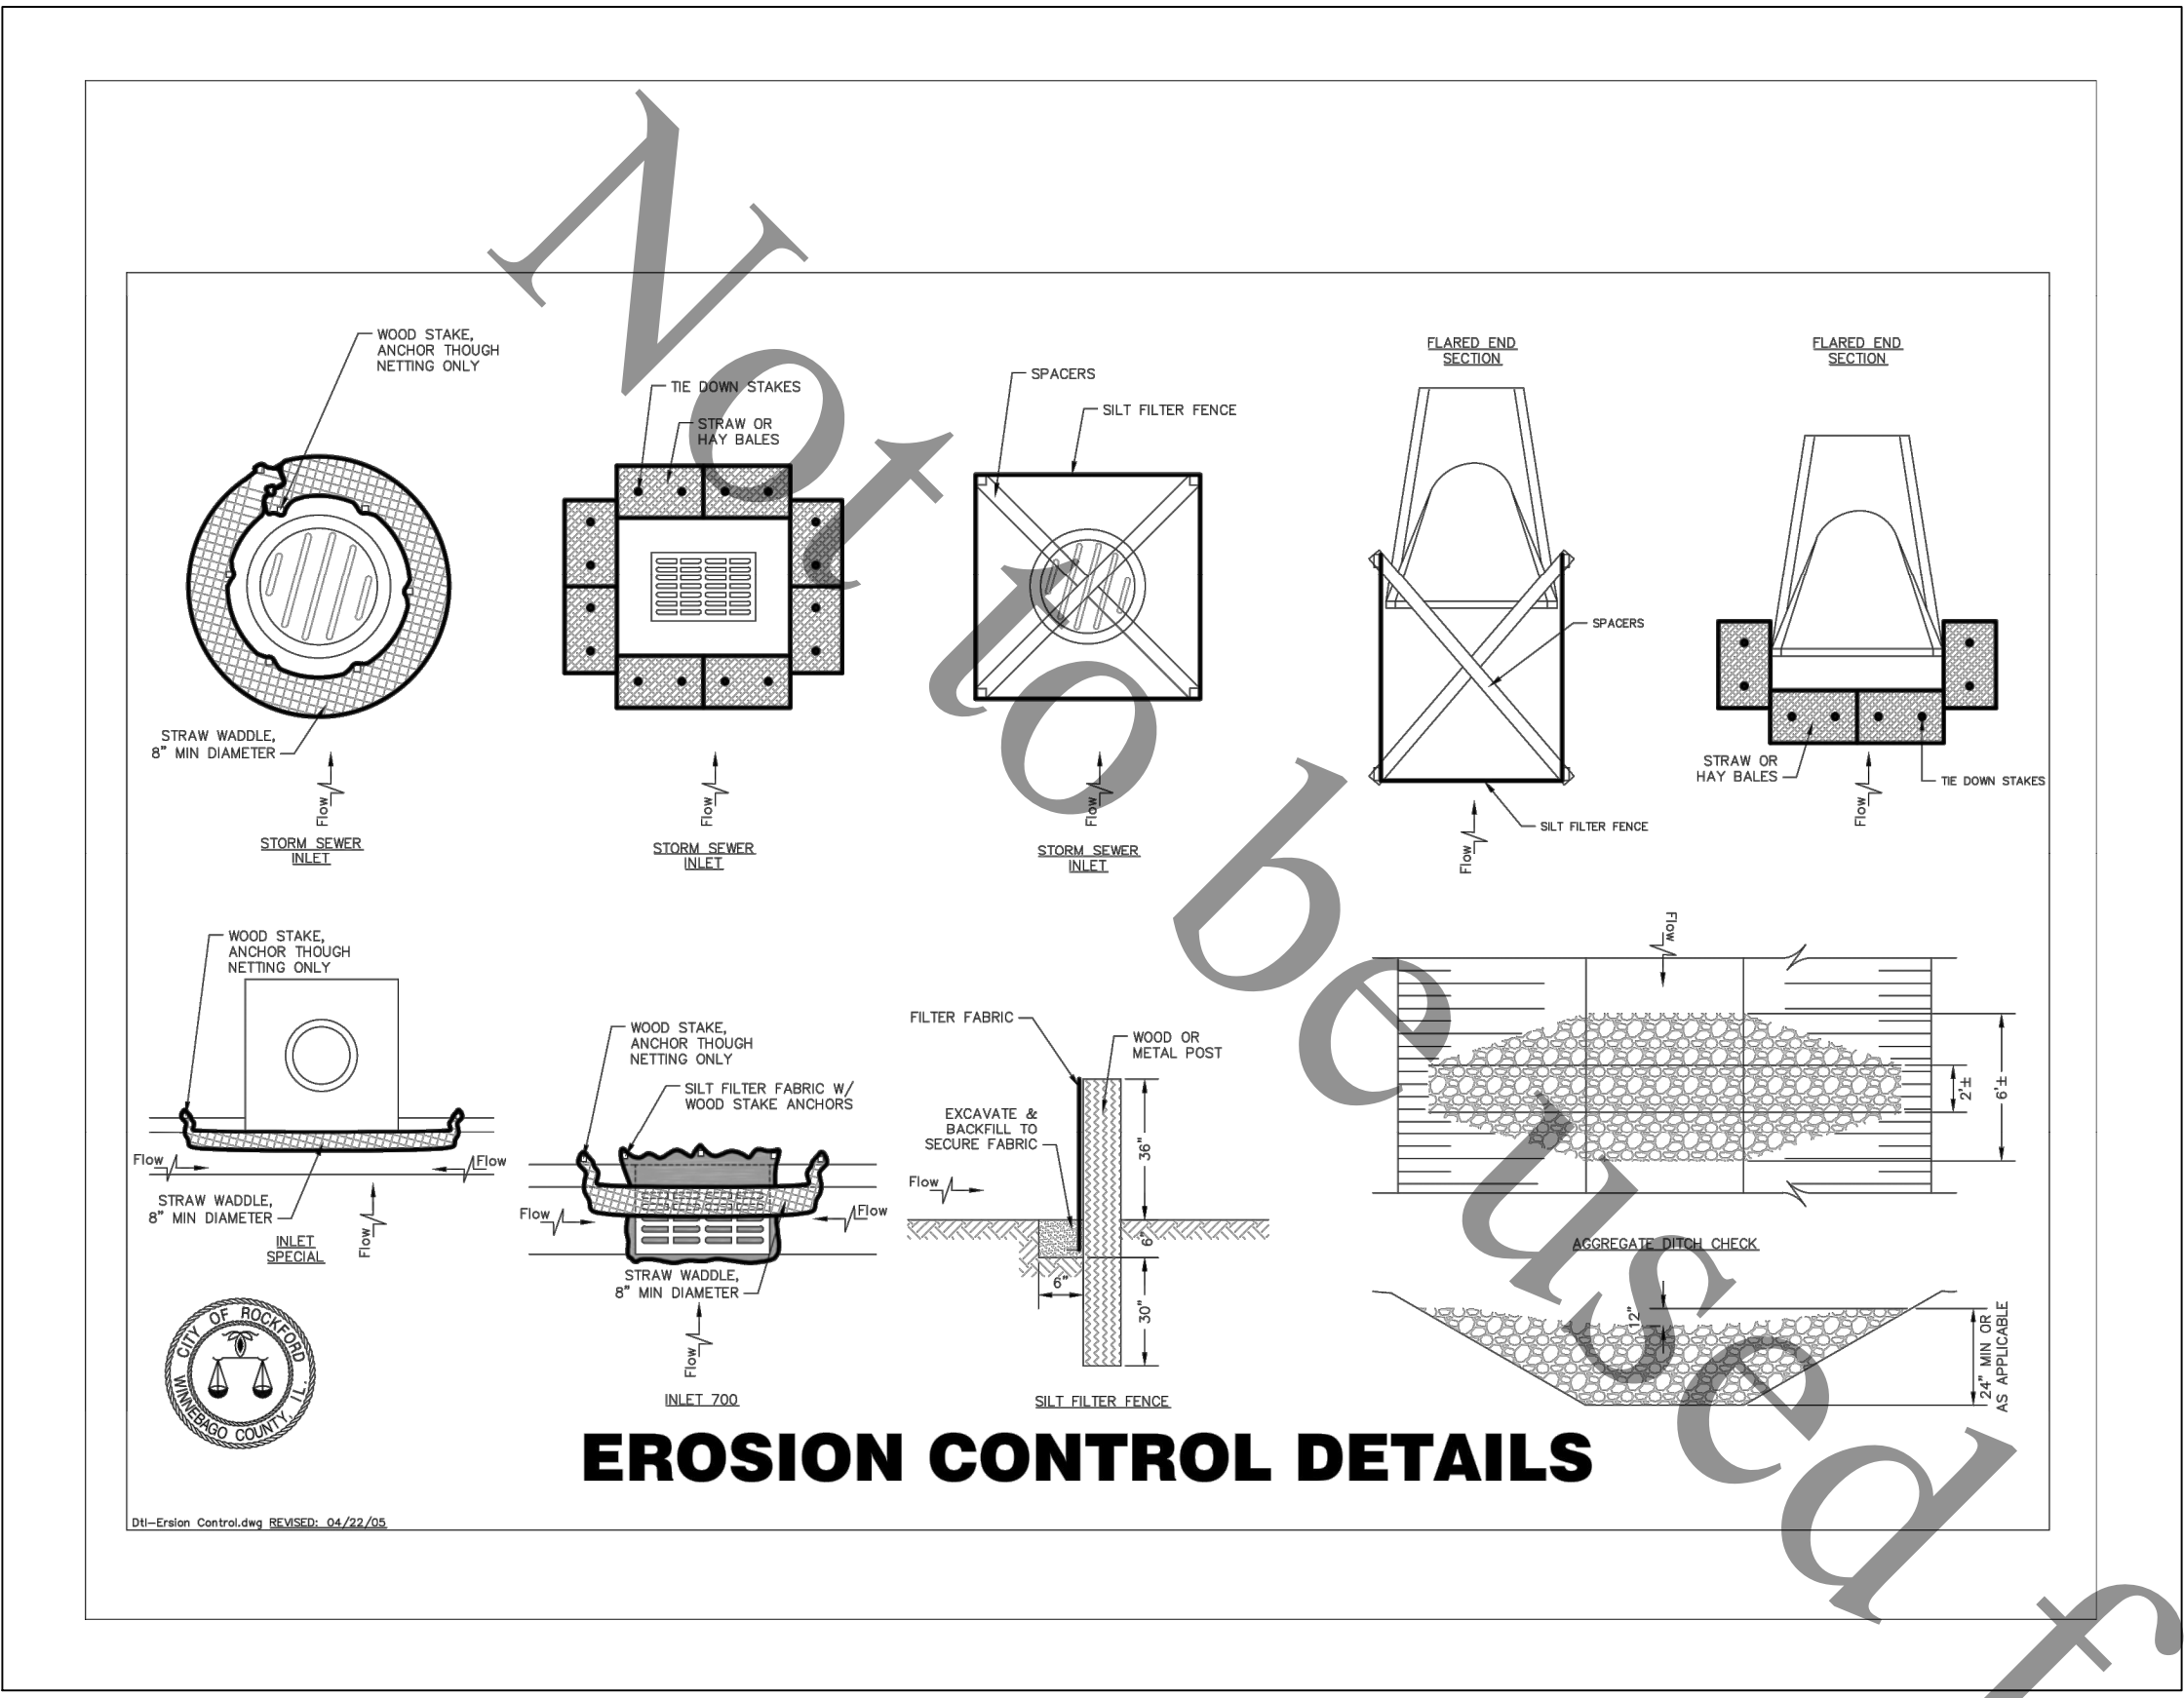

ROCK RIVER WATER
RECLAMATION DISTRICT
3501 KISHWAUKEE STREET
ROCKFORD, ILLINOIS 61109
(815) 387-7660

No.	DATE	REVISION	INT.


WEST STATE STREET SANITARY SEWER
CAPITAL IMPROVEMENT PROJECT NO. 2014

DETAILS (2)

FOR BID

Sheet No.
14 OF 15
Date
6/2/2021

3/2/2020 Revisions:
Manhole Adjustment Detail: deleted previous note 5, added/modified notes 3,4,5,6,9.
Rigid Pipe Bedding Detail: added leader pertaining to trench wall.
Flexible Pipe Bedding Detail: added leader pertaining to trench wall.
Flexible Saddle Connection Details (2): added note below detail name.

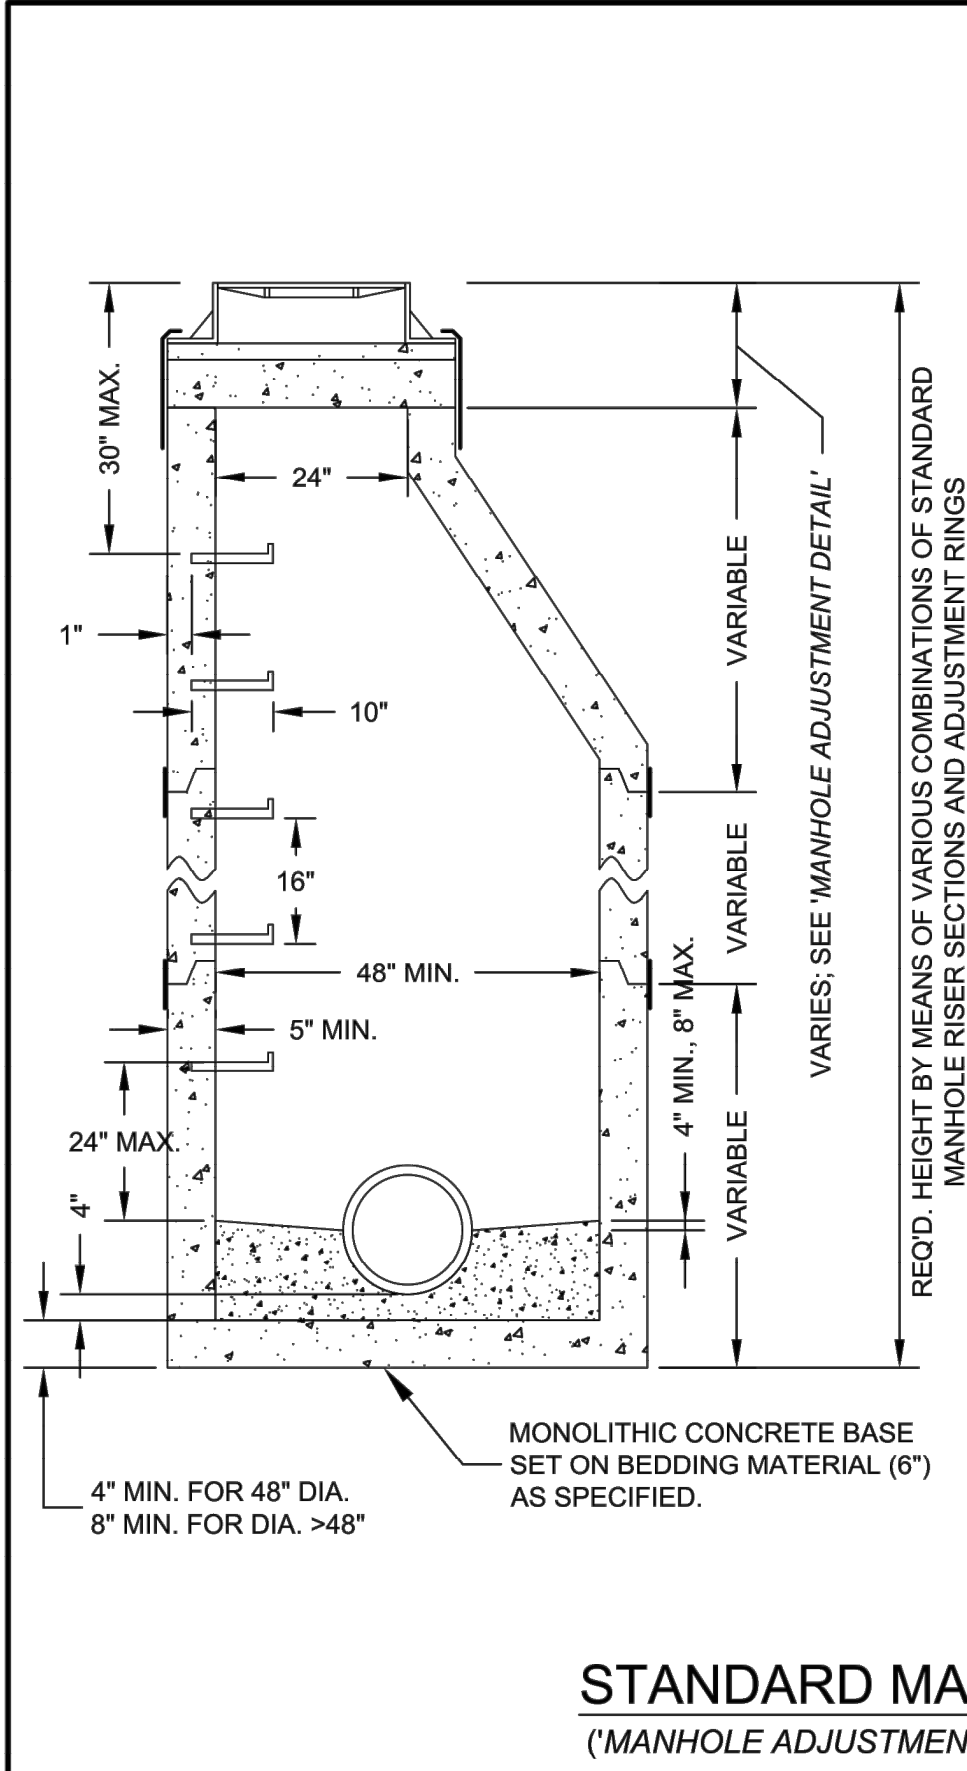


STANDARD MANHOLE DETAIL
(*MANHOLE ADJUSTMENT DETAIL* SHALL APPLY)

- NOTES:
1. THE MAX. DROP FROM THE INVERT OF ANY PIPE TO THE CONCRETE CHANNEL UNDER THAT PIPE SHALL BE 8".
 2. MANHOLES LOCATED OUTSIDE OF PUBLIC RIGHT-OF-WAY SHALL BE MARKED WITH A STEEL FENCE POST AS DIRECTED.
 3. ALL NEW MANHOLES SHALL BE VACUUM TESTED PER A.S.T.M. C-1244 PRIOR TO ACCEPTANCE.
 4. ALL BARREL JOINTS SHALL BE SEALED WITH 3 1/2" x 3/8" BITUMINOUS MATERIAL ON THE LOWER SHIPLAP.
 5. ALL BARREL JOINTS SHALL BE SEALED WITH AN EXTERNAL BARREL SEAL CENTERED ON THE JOINT (MAR MAC MACWRAP OR APPROVED EQUAL)
 6. MANHOLE STRUCTURE SHALL BE CONSTRUCTED OF PRECAST REINFORCED CONCRETE MANHOLE RISER SECTIONS IN ACCORDANCE WITH A.S.T.M. C478-90 OR THE LATEST DESIGNATION.
 7. PRECAST FLAT TOPS ARE NOT APPROVED FOR USE.
 8. SEE "MANHOLE ADJUSTMENT DETAIL" FOR ADJUSTMENT REQUIREMENTS.
 9. PIPE CONNECTIONS TO NEW MANHOLES SHALL BE MADE BY MEANS OF EITHER RUBBER GASKET SEAL (A-LOK OR APPROVED EQUAL) CONFORMING TO ASTM F-477 CAST INTEGRALLY IN MANHOLE WALL, OR RUBBER GASKET SEAL AND STAINLESS STEEL CLAMP (PSX SERIES SIX OR APPROVED EQUAL) CONFORMING TO ASTM C-923. FOR PIPE CONNECTIONS WITH A DEPTH OF >20 FT., A RUBBER GASKET SEAL (A-LOK OR APPROVED EQUAL) CONFORMING TO ASTM F-477 CAST INTEGRALLY IN MANHOLE WALL SHALL BE USED.
 10. PIPE CONNECTIONS TO EXISTING MANHOLES SHALL BE MADE BY MEANS OF CORE DRILLING MANHOLE WALL AND INSTALLING RUBBER GASKET SEAL AND STAINLESS STEEL CLAMP (PSX SERIES SIX OR APPROVED EQUAL) CONFORMING TO ASTM C-923.
 11. THE MAXIMUM DISTANCE FROM ANY INLET PIPE INVERT TO THE OUTLET PIPE INVERT SHALL BE 2'. A DISTANCE GREATER THAN 2' WILL REQUIRE AN INSIDE DROP CONNECTION PER "INSIDE DROP MANHOLE DETAIL".
 12. MANHOLE STEPS SHALL BE NEENAH R-1982-F OR M.A. IND. PS-1 OR APPROVED EQUAL AT 16" CENTERS.

rev. 4/11/19


- NOTES:
1. MANHOLE FRAME & LID SHALL BE NEENAH R-1670 OR EAST JORDAN E-1117 WITH NON-ROCKING & SELF-SEALING LID.
 2. LID SHALL HAVE 2" HIGH "SANITARY" LETTERING & A CONCEALED PICK HOLE.
 3. ALLOWABLE TYPES OF ADJUSTING RINGS INCLUDE PRECAST CONCRETE, HIGH DENSITY POLYETHYLENE (HDPE), & EXPANDED POLYPROPYLENE (EPP). THESE CAN BE USED IN CONJUNCTION WITH EACH OTHER, EXCEPT THAT A PRECAST RING SHALL NOT BE PLACED OVER AN HDPE OR EPP RING.
 4. FOR PRECAST ADJUSTING RINGS, ALL ADJUSTING RING JOINTS AS WELL AS THE FRAME TO ADJUSTING RING JOINT SHALL BE SEALED WITH TWO 1" BEADS OF PRE-FORMED RUBBER BUTYL JOINT SEALER, INCLUDING FRAME TO CONCRETE JOINT. WHEN A FRAME REQUIRES PITCHING, A MIN. OF 3 SHIMS EQUALLY SPACED SHALL BE INSTALLED BETWEEN THE FRAME AND CONCRETE AND HYDRAULIC CEMENT SHALL BE USED TO FILL THE VOID BETWEEN THE FRAME & CONCRETE.
 5. FOR HDPE OR EPP ADJUSTING RINGS, THE MAX. AMOUNT OF ADJUSTMENT IS 3" FOR HDPE & 6" FOR EPP. HDPE & EPP RINGS SHALL BE INSTALLED ACCORDING TO MANUFACTURER'S INSTRUCTIONS. WHEN A FRAME REQUIRES PITCHING, THE TOP RING SHALL BE AN 'ADJUSTMENT' RING PER MANUFACTURER'S INSTRUCTIONS.
 6. NO TARRING OR GROUTING IS ALLOWED ON THE INSIDE OF MANHOLE OR ADJUSTMENT JOINTS.

MANHOLE ADJUSTMENT DETAIL
(FOR ADJUSTMENT OF BOTH NEW & EXISTING MANHOLES)

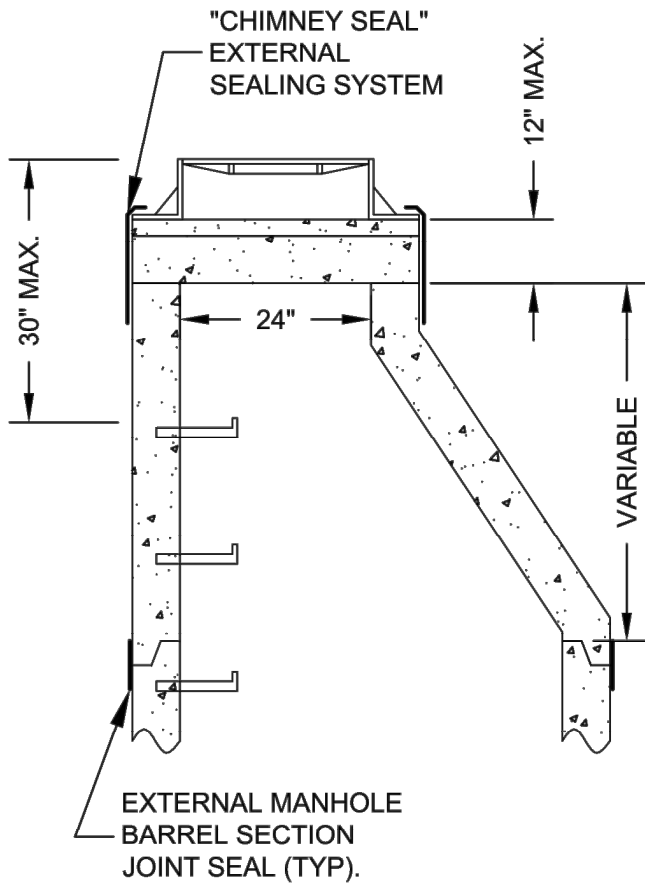

rev. 3/11/20


DROP BOWL & DROP PIPE SIZING TABLE	
INLET PIPE DIA.	DROP PIPE DIA. (MIN.)
4-6 INCH	4 INCH
8 INCH	6 INCH
10 INCH	8 INCH
>10 INCH	*
* PER MFG. OR AS DIRECTED BY RRWRD	

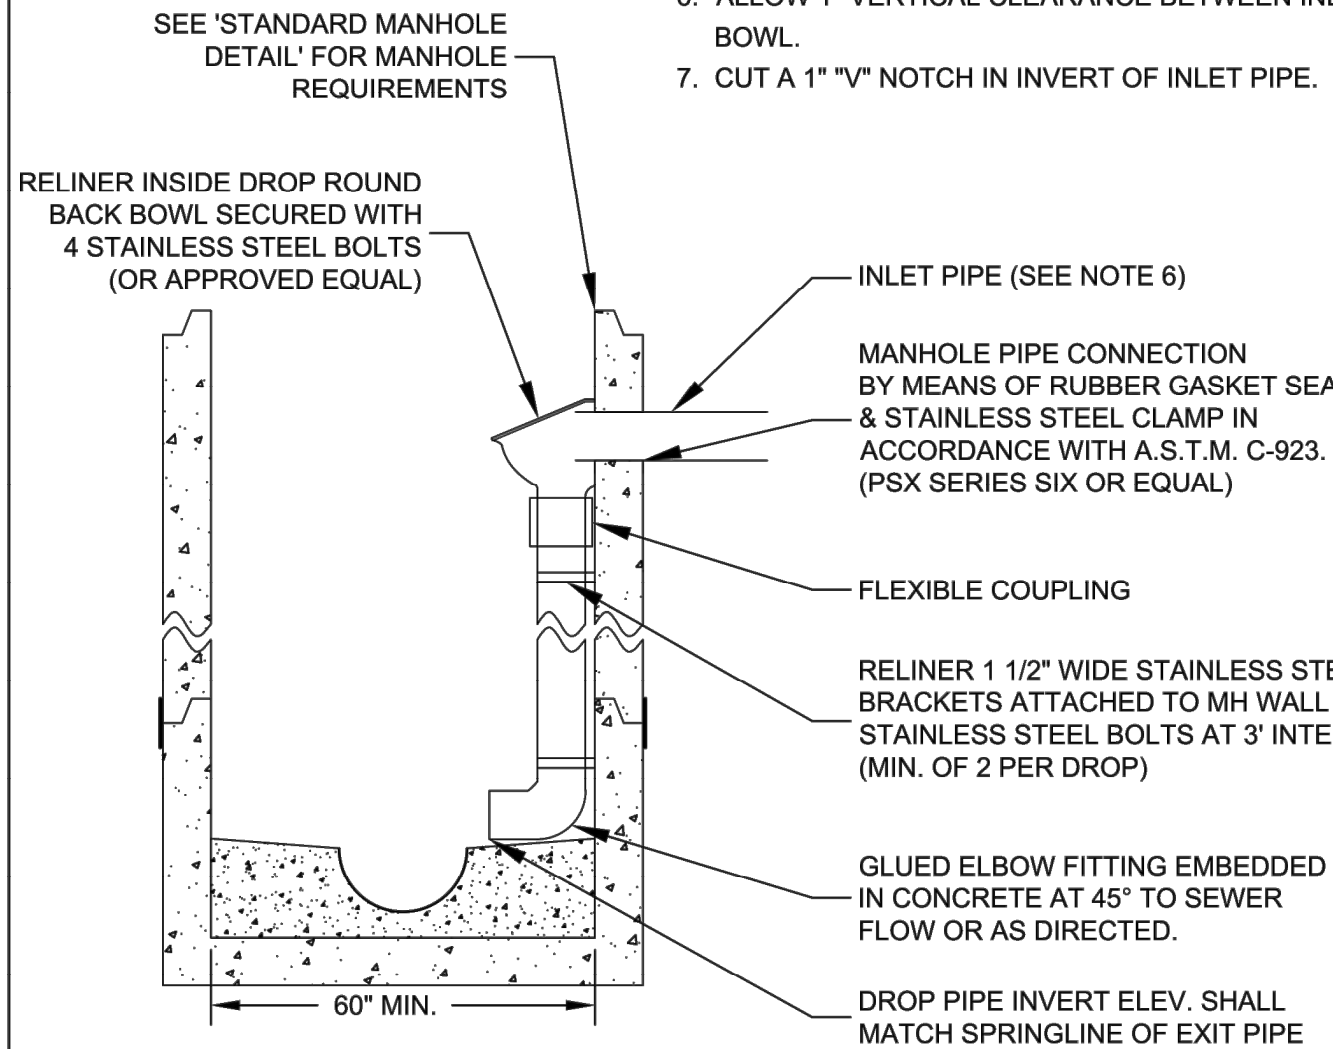

INSIDE DROP MANHOLE DETAIL
(*STANDARD MANHOLE DETAIL* SHALL APPLY)

- NOTES:
1. INSIDE DROP TYPE MANHOLES SHALL BE 5' MIN. INSIDE DIA.
 2. ALL INSIDE DROP TYPE CONNECTIONS FOR SERVICES AND COLLECTOR SEWERS SHALL USE THE DROP AS PRODUCED BY RELINER-DURAN INC. OR EQUAL.
 3. SEE TABLE FOR DROP BOWL AND DROP PIPE SIZES.
 4. ALL INSIDE DROP PIPING SHALL BE PVC SDR35 ASTM-D3034.
 5. ATTACH THE ROUND BACK DROP BOWL AND EACH CLAMPING BRACKET TO THE MANHOLE WALL WITH 3/8"x 1" MIN. STAINLESS STEEL BOLTS AND EPOXY IMPREGNATED LUGS PER MFG. RECOMMENDATIONS.
 6. ALLOW 1" VERTICAL CLEARANCE BETWEEN INLET PIPE & BOWL.
 7. CUT A 1" "V" NOTCH IN INVERT OF INLET PIPE.


rev. 5/15/18

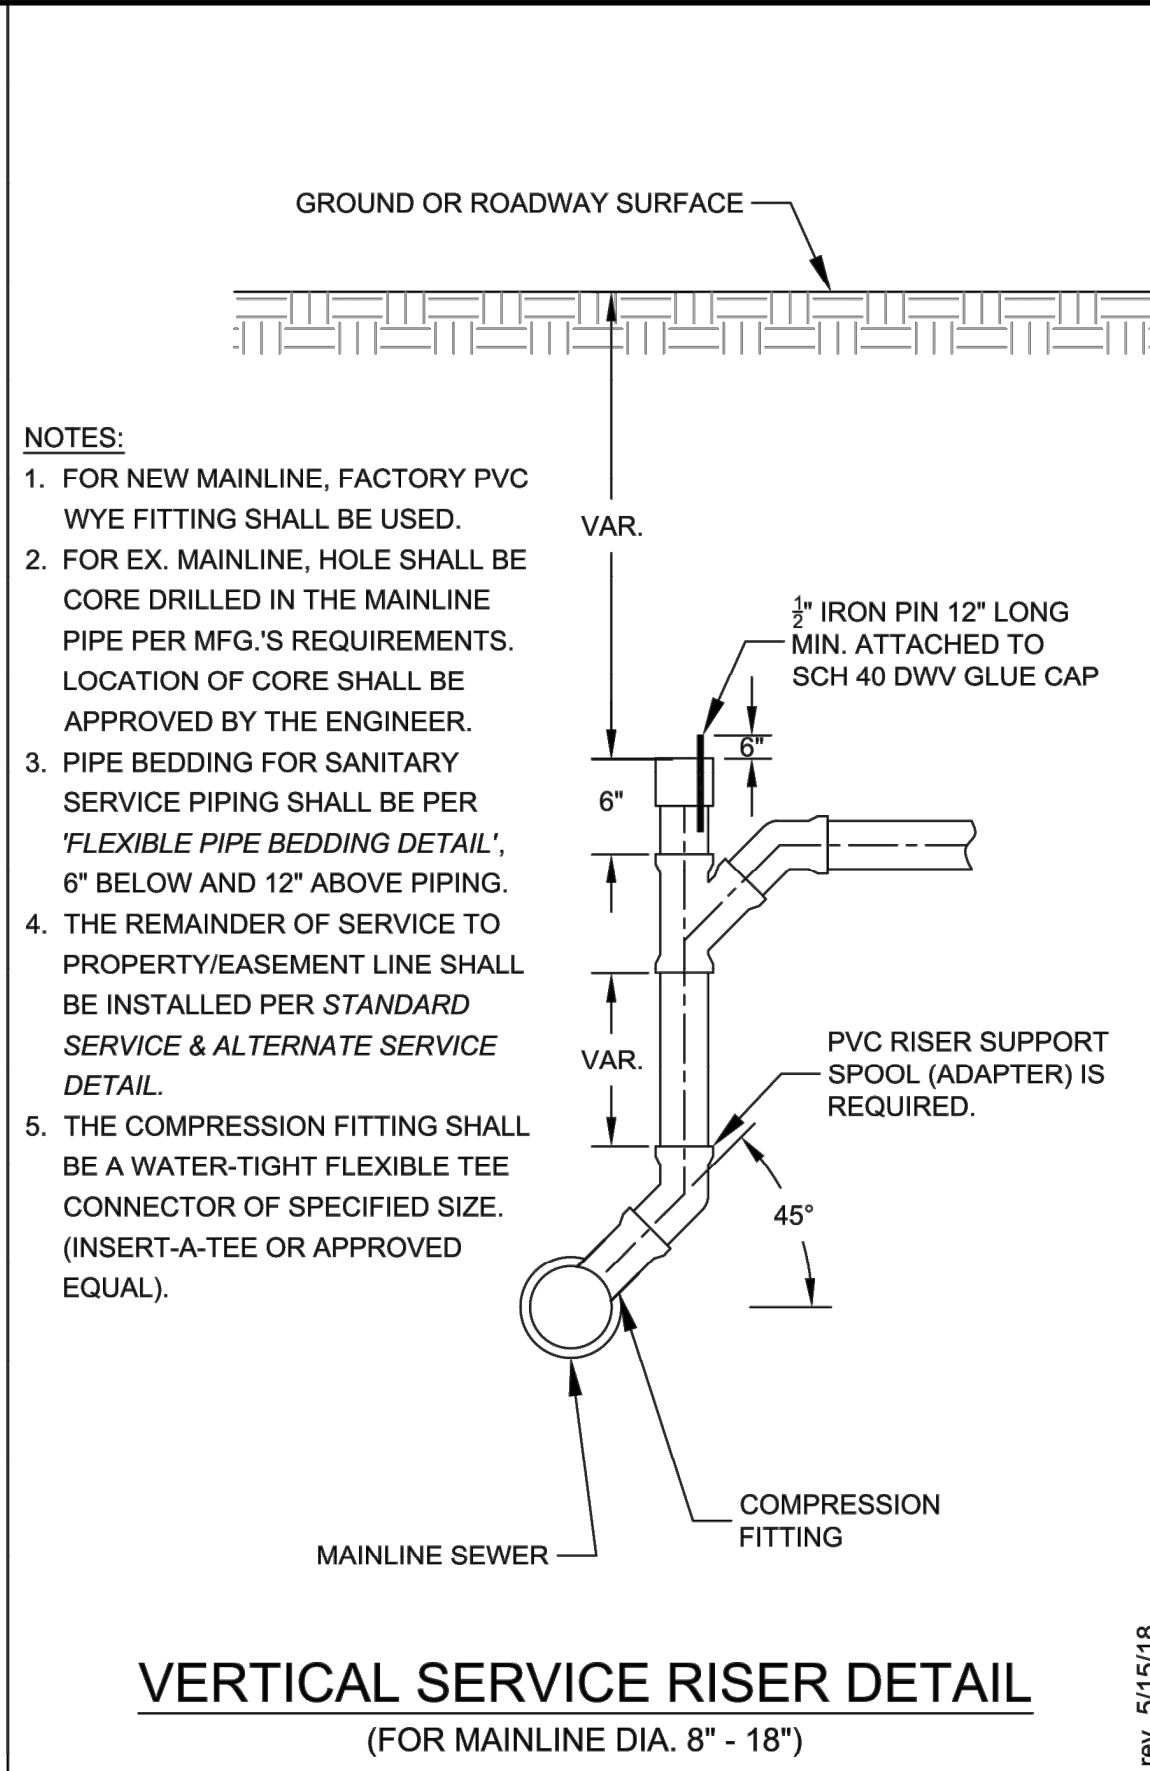

- NOTES:
1. FOR NEW MAINLINE, FACTORY PVC WYE FITTING SHALL BE USED.
 2. FOR EX. MAINLINE, HOLE SHALL BE CORE DRILLED IN THE MAINLINE PIPE PER MFG.'S REQUIREMENTS. LOCATION OF CORE SHALL BE APPROVED BY THE ENGINEER.
 3. PIPE BEDDING FOR SANITARY SERVICE PIPING SHALL BE PER 'FLEXIBLE PIPE BEDDING DETAIL', 6" BELOW AND 12" ABOVE PIPING.
 4. THE REMAINDER OF SERVICE TO PROPERTY/EASEMENT LINE SHALL BE INSTALLED PER STANDARD SERVICE & ALTERNATE SERVICE DETAIL.
 5. THE COMPRESSION FITTING SHALL BE A WATER-TIGHT FLEXIBLE TEE CONNECTOR OF SPECIFIED SIZE. (INSERT-A-TEE OR APPROVED EQUAL).

rev. 5/15/18


- NOTES:
1. REASONABLE CARE SHALL BE USED WHEN BACKFILLING OVER SEWER. NO MATERIALS SUCH AS ROCKS OR BOULDERS SHALL BE PLACED WITHIN 24" OF THE CROWN OF THE PIPE. NO MATERIAL LARGER THAN 8" DIA. SHALL BE USED IN THE BACKFILL.
 2. LOOSE MATERIAL TO BE REMOVED OR COMPACTED PRIOR TO PLACING PIPE BEDDING.
 3. BEDDING SHALL BE WELL HAUNCHED ALONG PIPE TO ENSURE VOIDS ARE ELIMINATED.

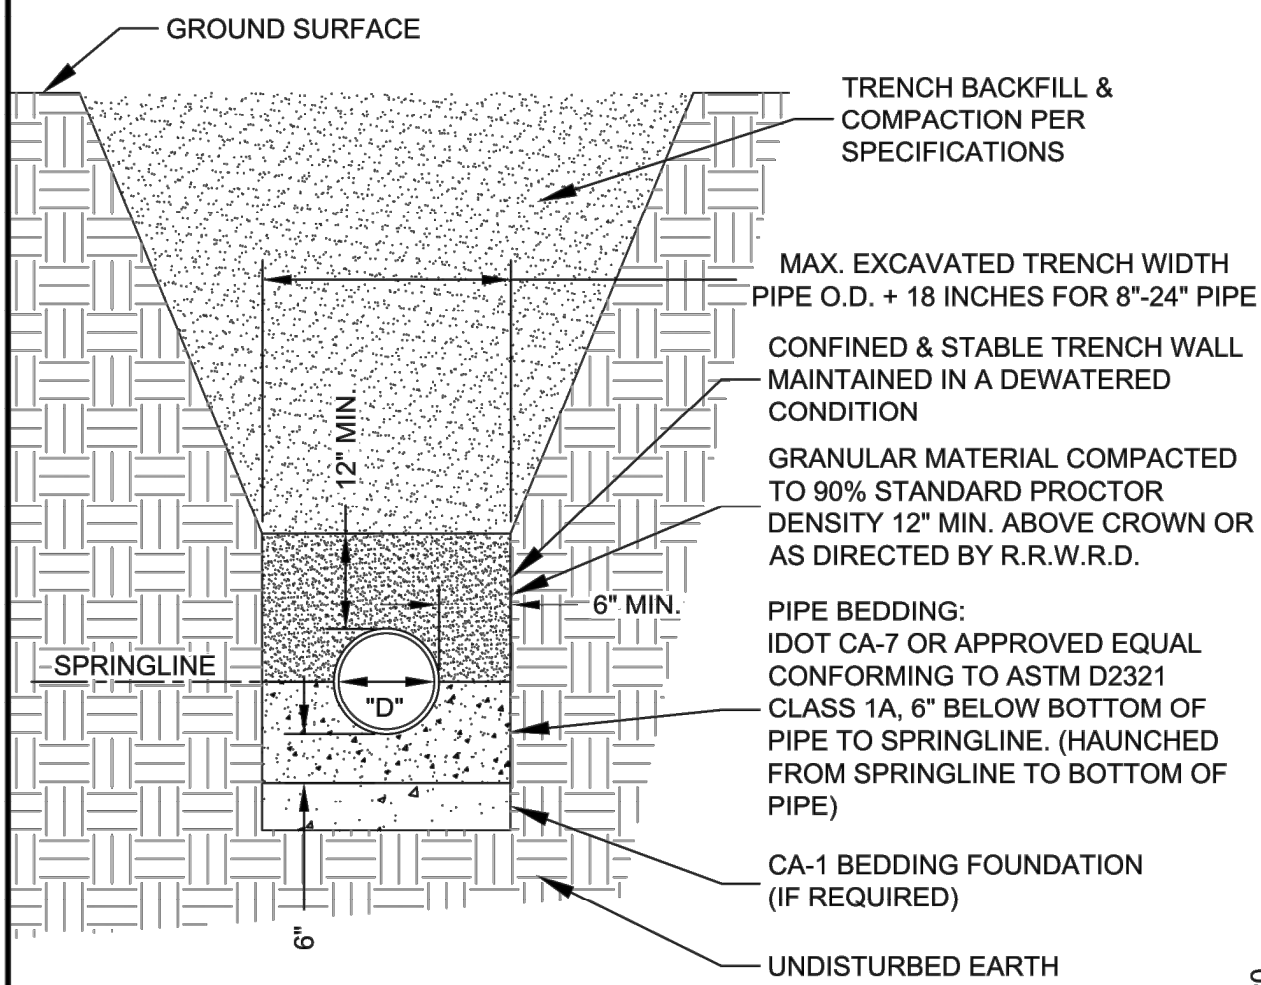

RIGID PIPE BEDDING DETAIL


rev. 3/11/20

- NOTES:
1. REASONABLE CARE SHALL BE USED WHEN BACKFILLING OVER SEWER. NO MATERIALS SUCH AS ROCKS OR BOULDERS SHALL BE PLACED WITHIN 24" OF THE CROWN OF THE PIPE. NO MATERIAL LARGER THAN 8" DIA. SHALL BE USED IN THE BACKFILL.
 2. LOOSE MATERIAL TO BE REMOVED OR COMPACTED PRIOR TO PLACING PIPE BEDDING.
 3. BEDDING SHALL BE WELL HAUNCHED ALONG PIPE TO ENSURE VOIDS ARE ELIMINATED.

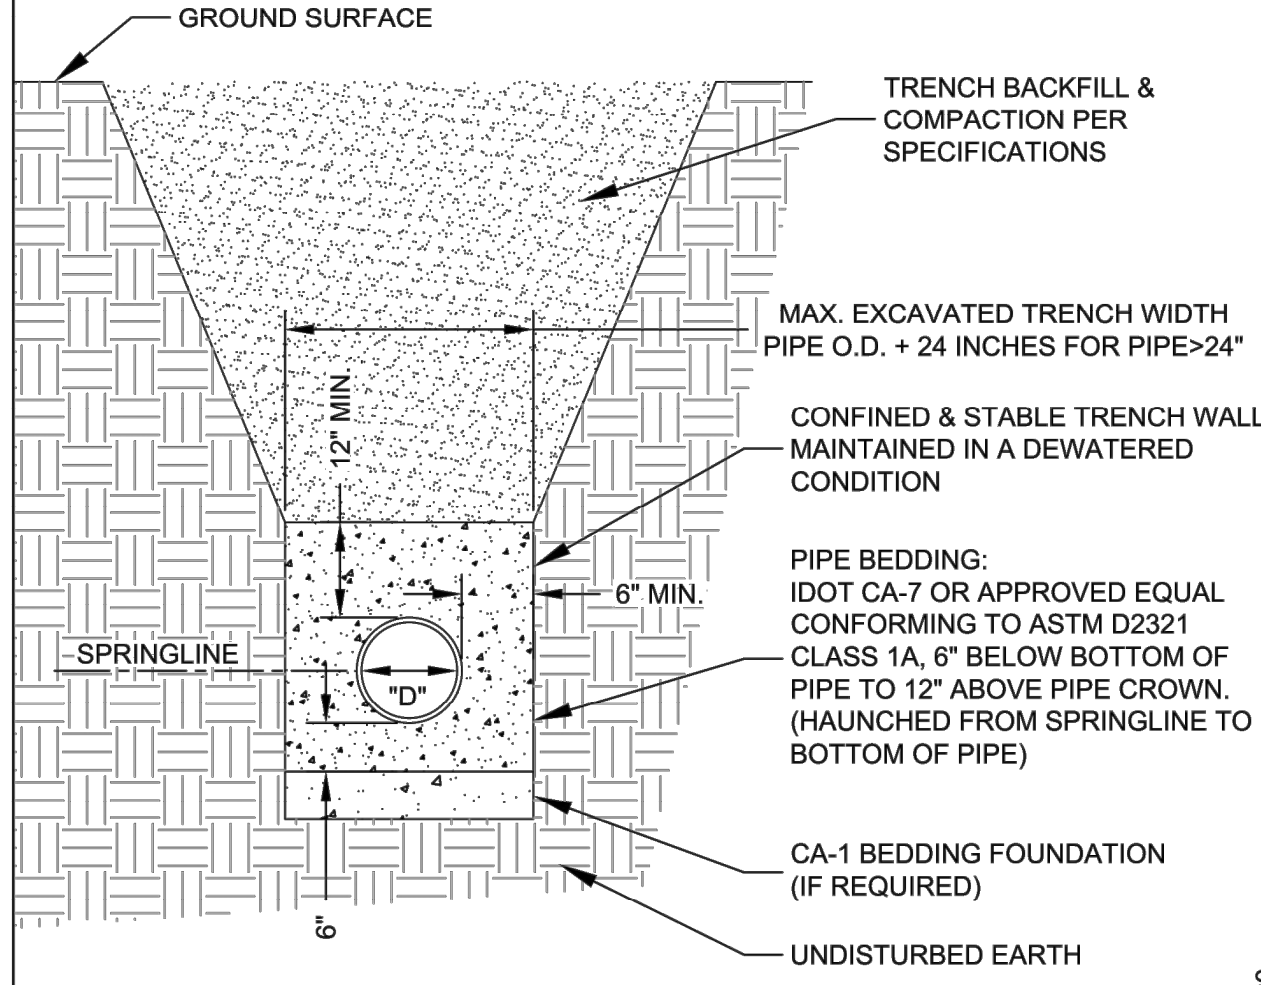


FLEXIBLE PIPE BEDDING DETAIL

rev. 3/11/20

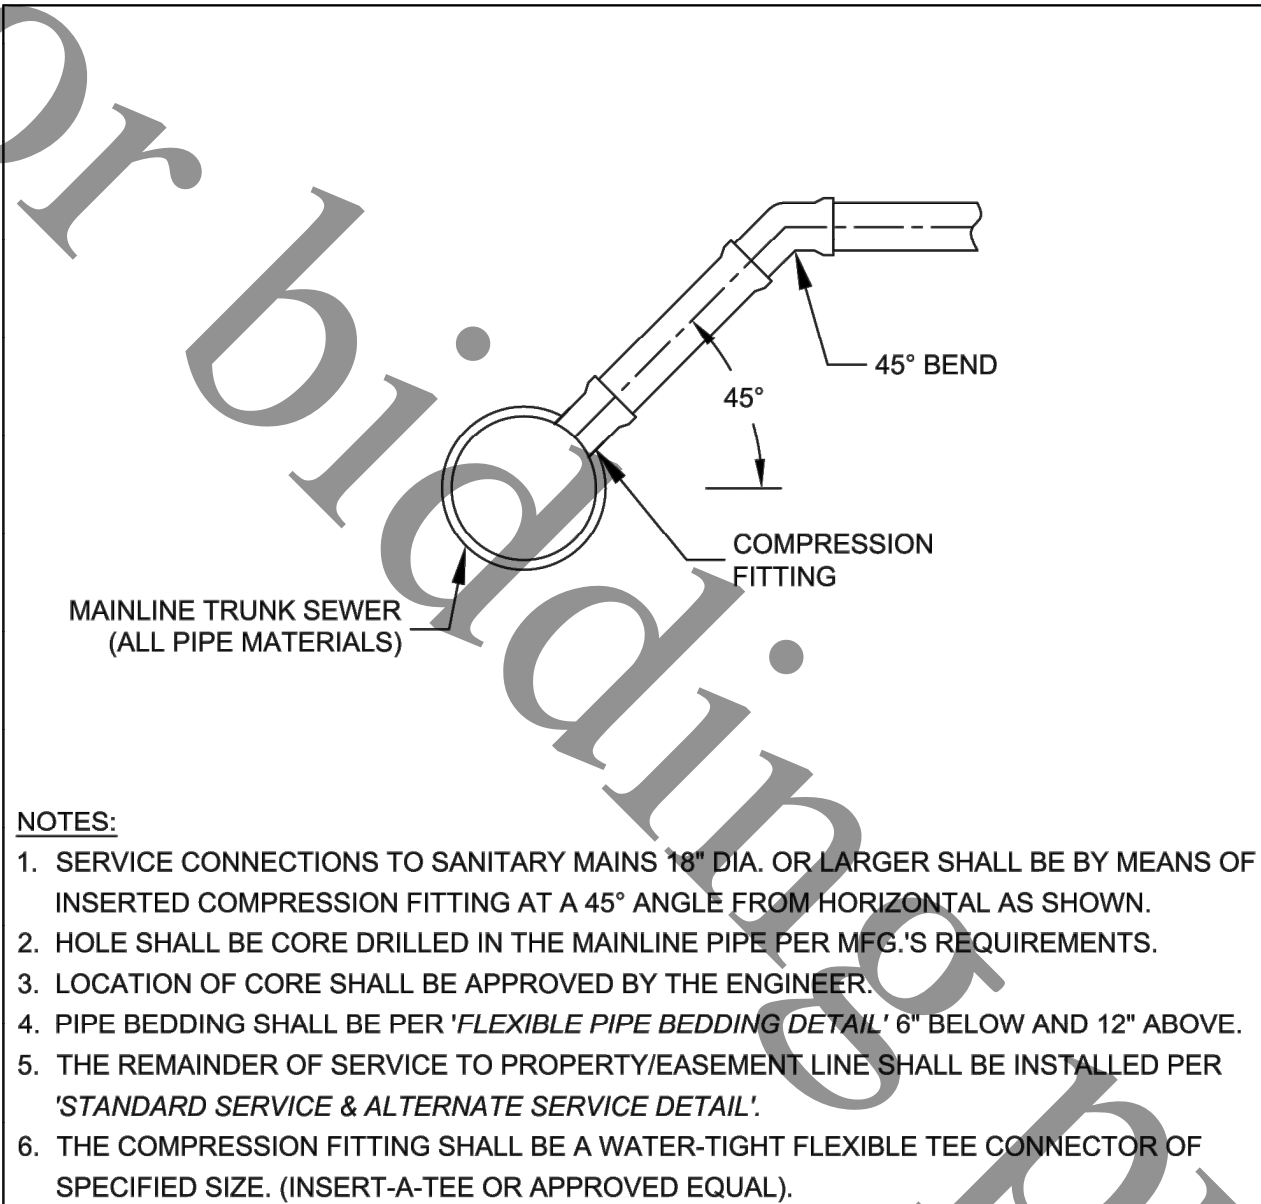

SERVICE CONNECTION DETAIL FOR CONNECTION TO 18" DIA. OR LARGER PIPE


rev. 3/11/20

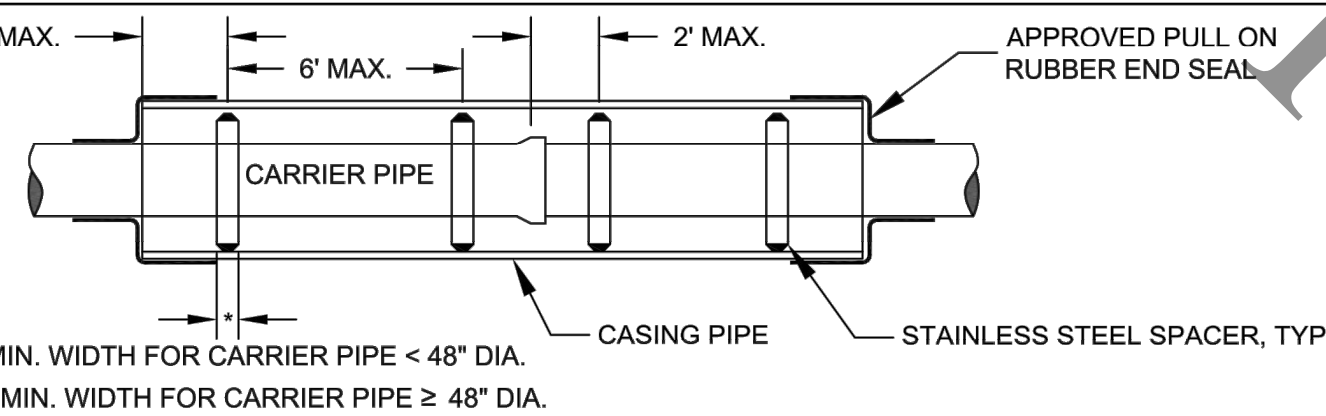

- NOTES:
1. CASING END SEALS & SPACERS SHALL BE AS MFG. BY CASCADE MFG., OR APPROVED EQUAL.
 2. FOR FLEXIBLE CARRIER PIPE, SPACING OF SPACERS TO BE AS SHOWN, OR PER MFG.'S RECOMMENDATION.
 3. FOR RIGID CARRIER PIPE, SPACING SHALL BE PER MFG.'S RECOMMENDATION.


CASING & SPACER DETAIL

rev. 5/15/18

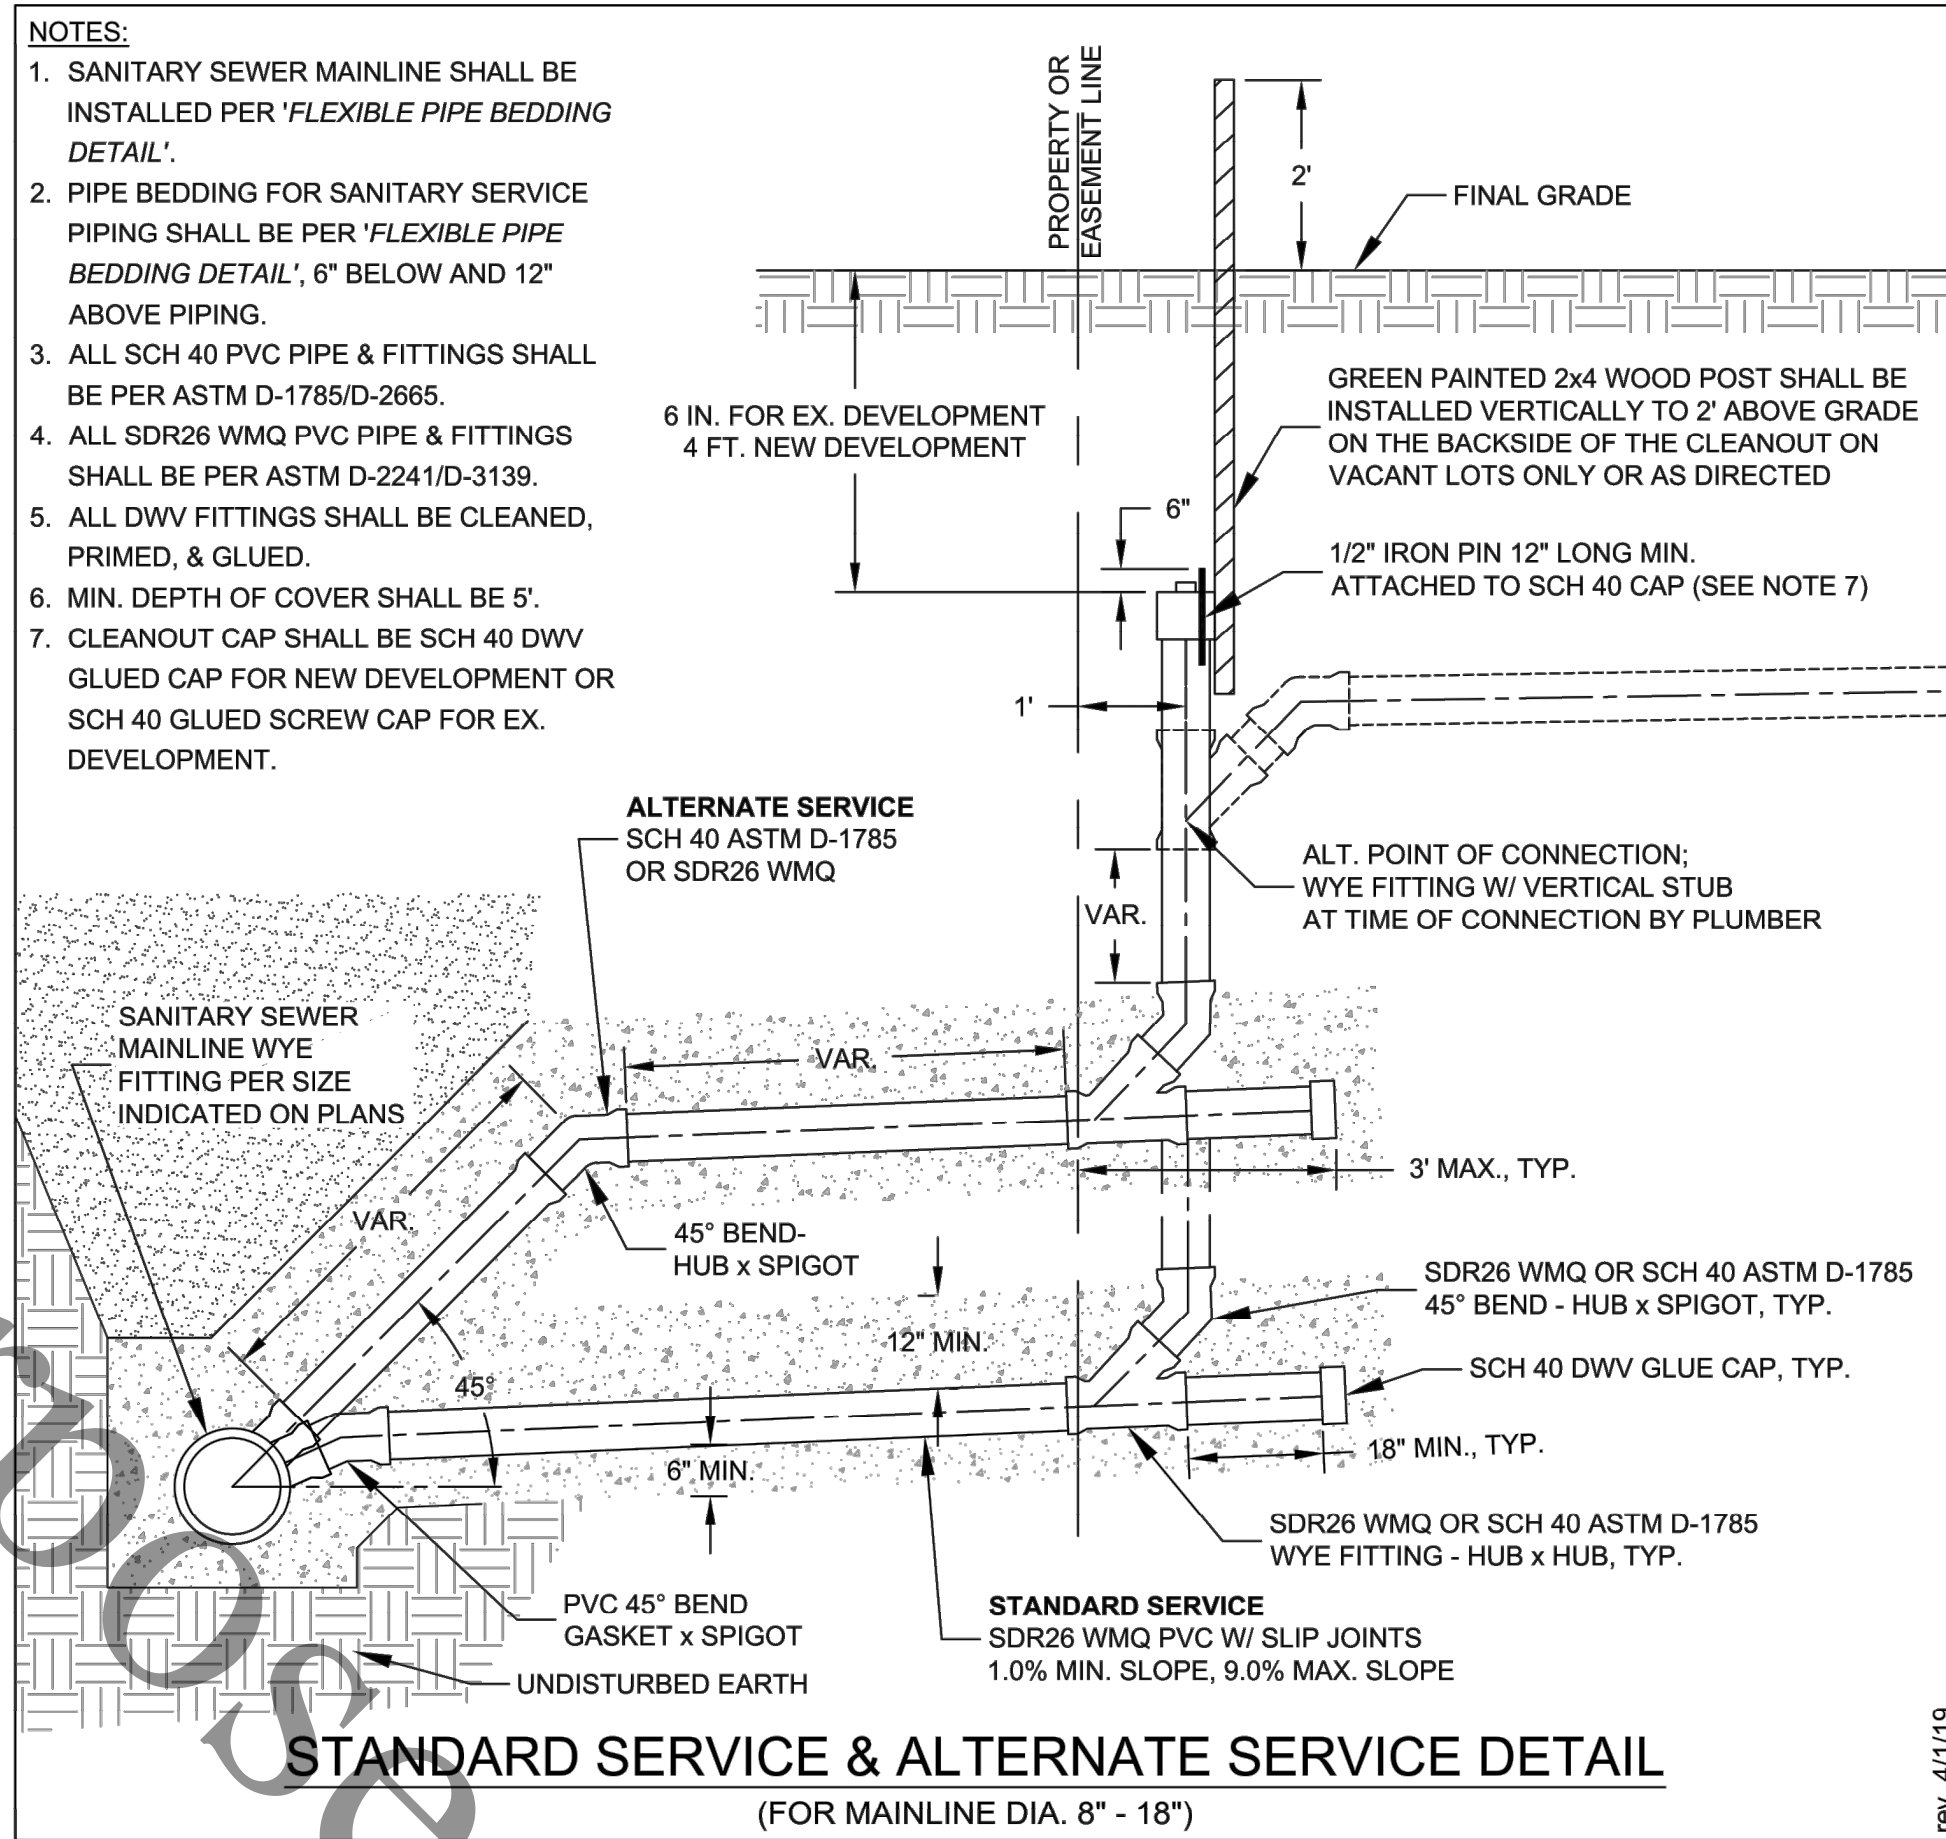

STANDARD SERVICE & ALTERNATE SERVICE DETAIL
(FOR MAINLINE DIA. 8" - 18")

rev. 4/11/19

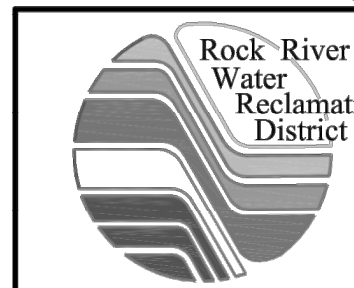

ROCK RIVER WATER RECLAMATION DISTRICT
STANDARD DETAIL SHEET
(NOT TO SCALE)

3501 KISHWAUKEE ST. P.O. BOX 7480
ROCKFORD, ILLINOIS 61109 PH. (815) 387-7660

15 OF 15

ISSUE 3/11/2020